




3D VIEW OF OXYGEN MORE TOILET



INTERIOR VIEW (MALE ZONE)

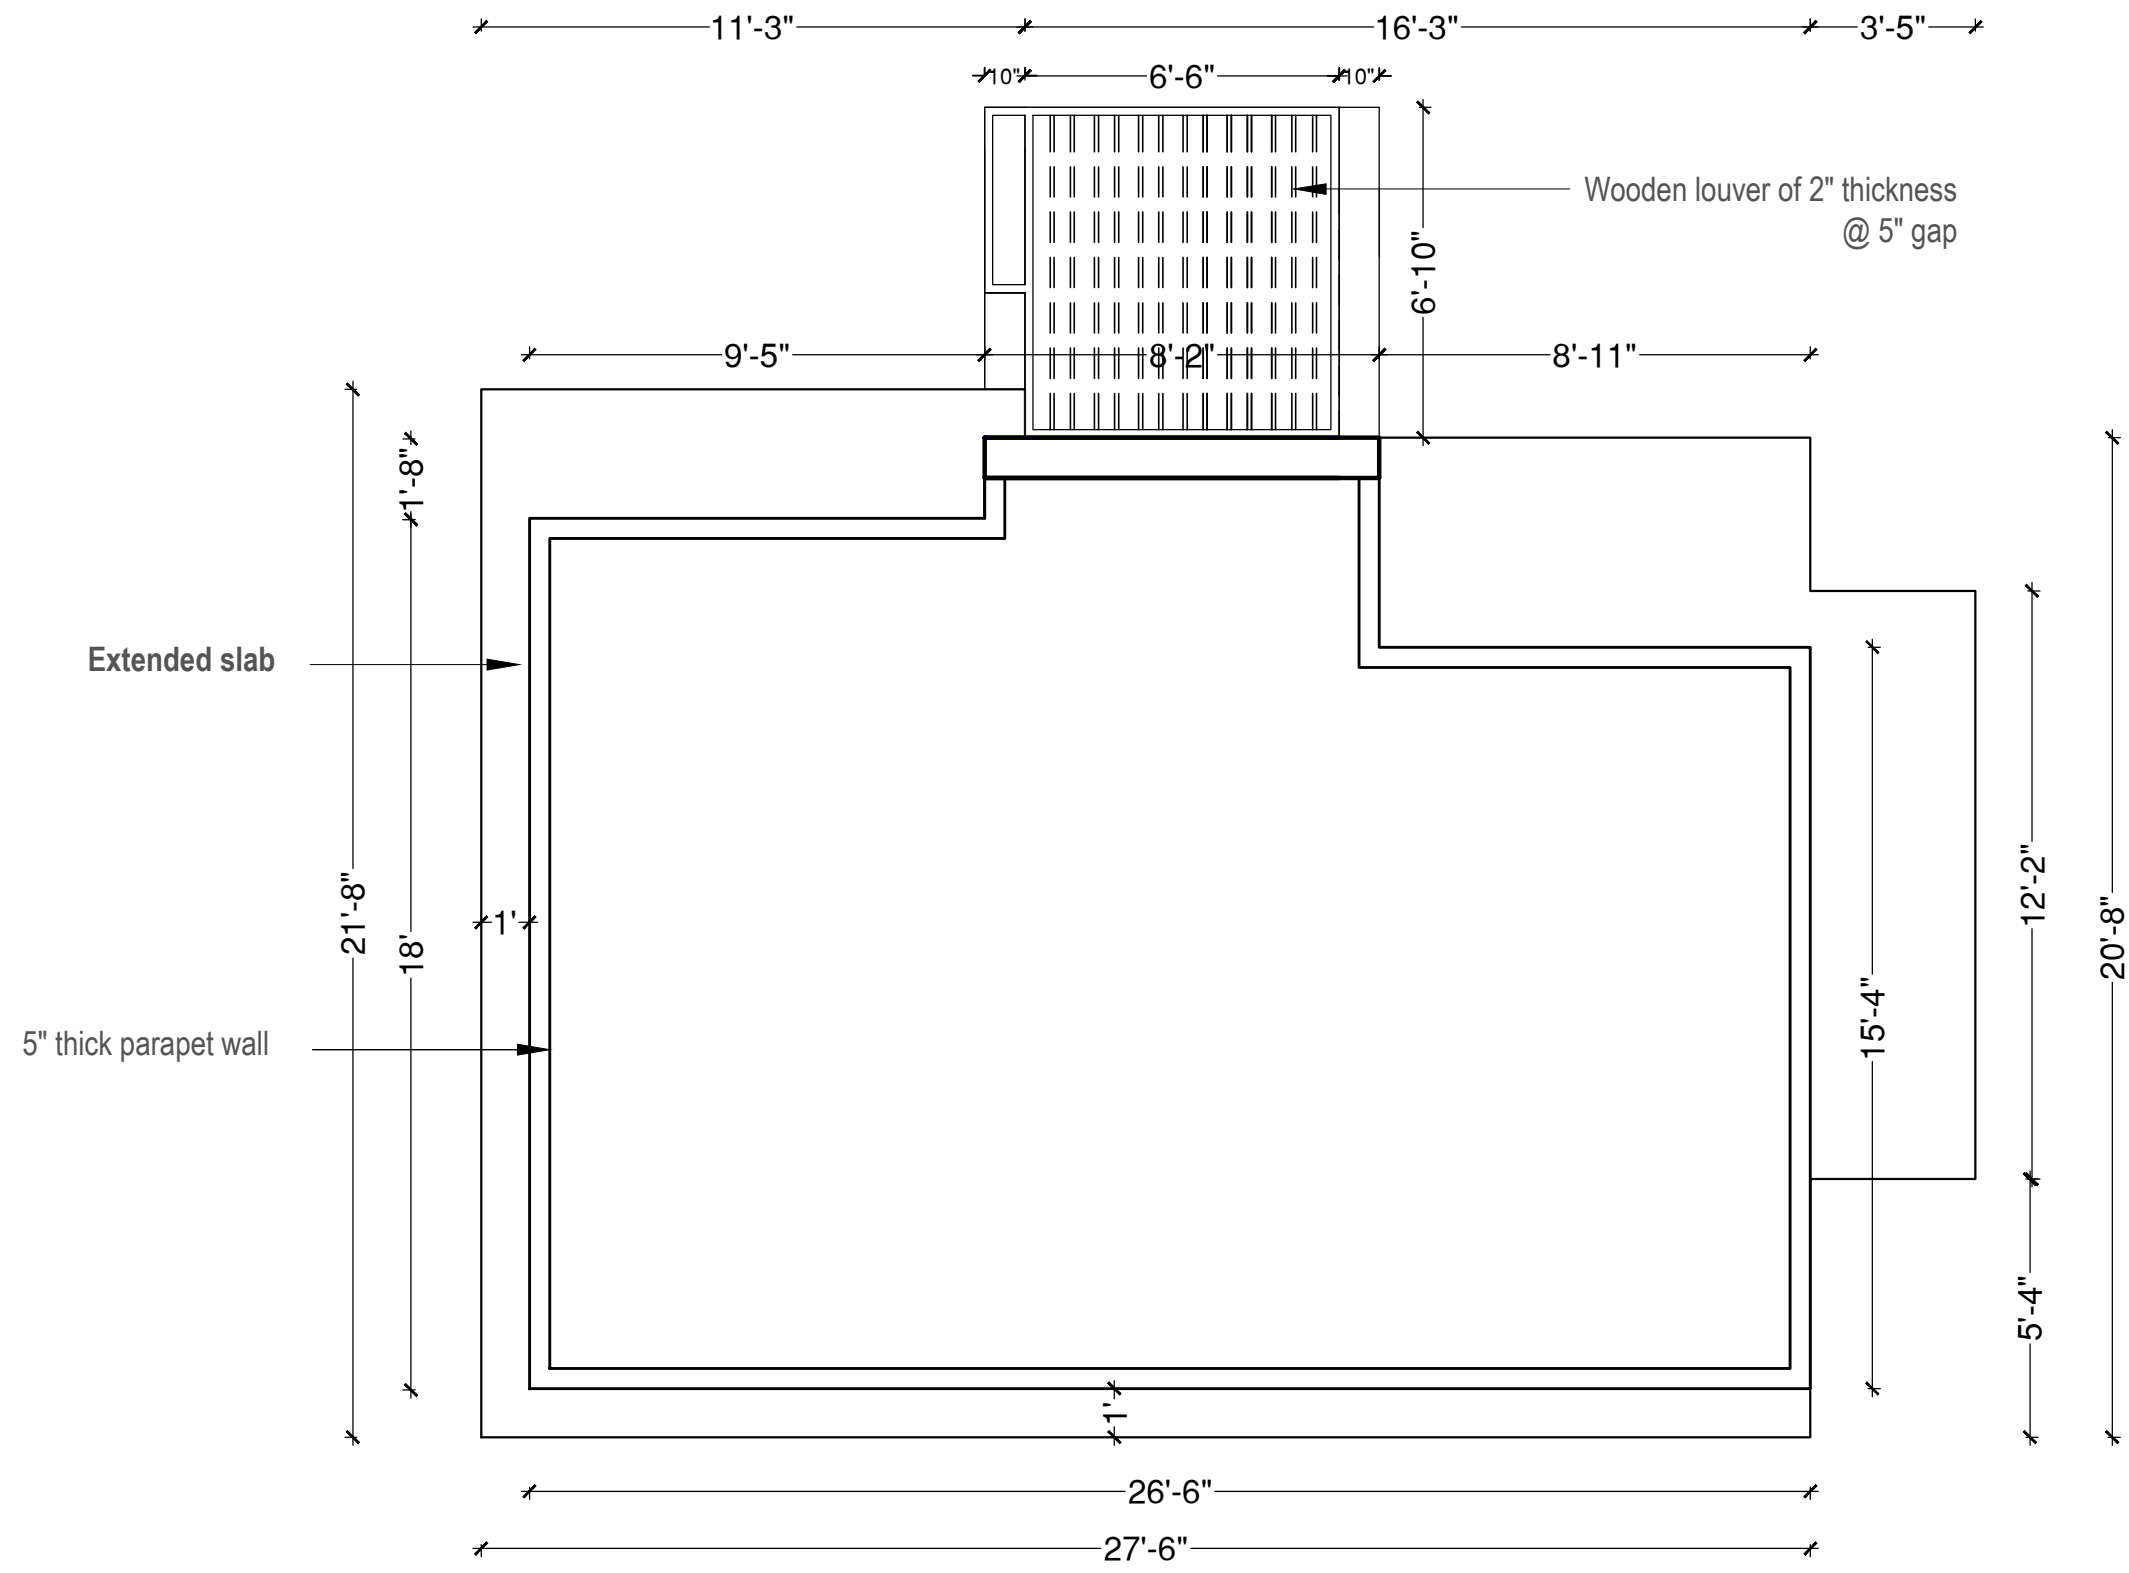

W
N ROOF PLAN

Project
Proposed Design of Public Toilet
at Oxygen more, Chittagong

Project Location
Chittagong

Client
DSK
WATER AID

Drawing Title
ROOF PLAN

Scale
1' 1' 2' 4' 8'

Date
03.02.2018

Drawing Number
A-3


Drawing Option

Design Team
Architect
Ashraful Alum
B. Arch. BUET
Fahmida Haque
B. Arch. BUET
Md. Tanvir Hossain Chowdhury
B. Arch. SUB
Samanta Safrina Zahir
B. Arch. AUST

Engineer
Md. Moshir Rahman
B.Sc. Civil, UAP
Md.Fuhad Mollah
B.Sc. Civil, UITs

Consultant
IDYLLIC DESIGN


Flat- F3(2ndFloor), Raja Villa, 113 Lake
Circus, Dhaka-1205,Bangladesh
Phone : 9611397-8, 01713044077
email : idyllicdesign11@gmail.com

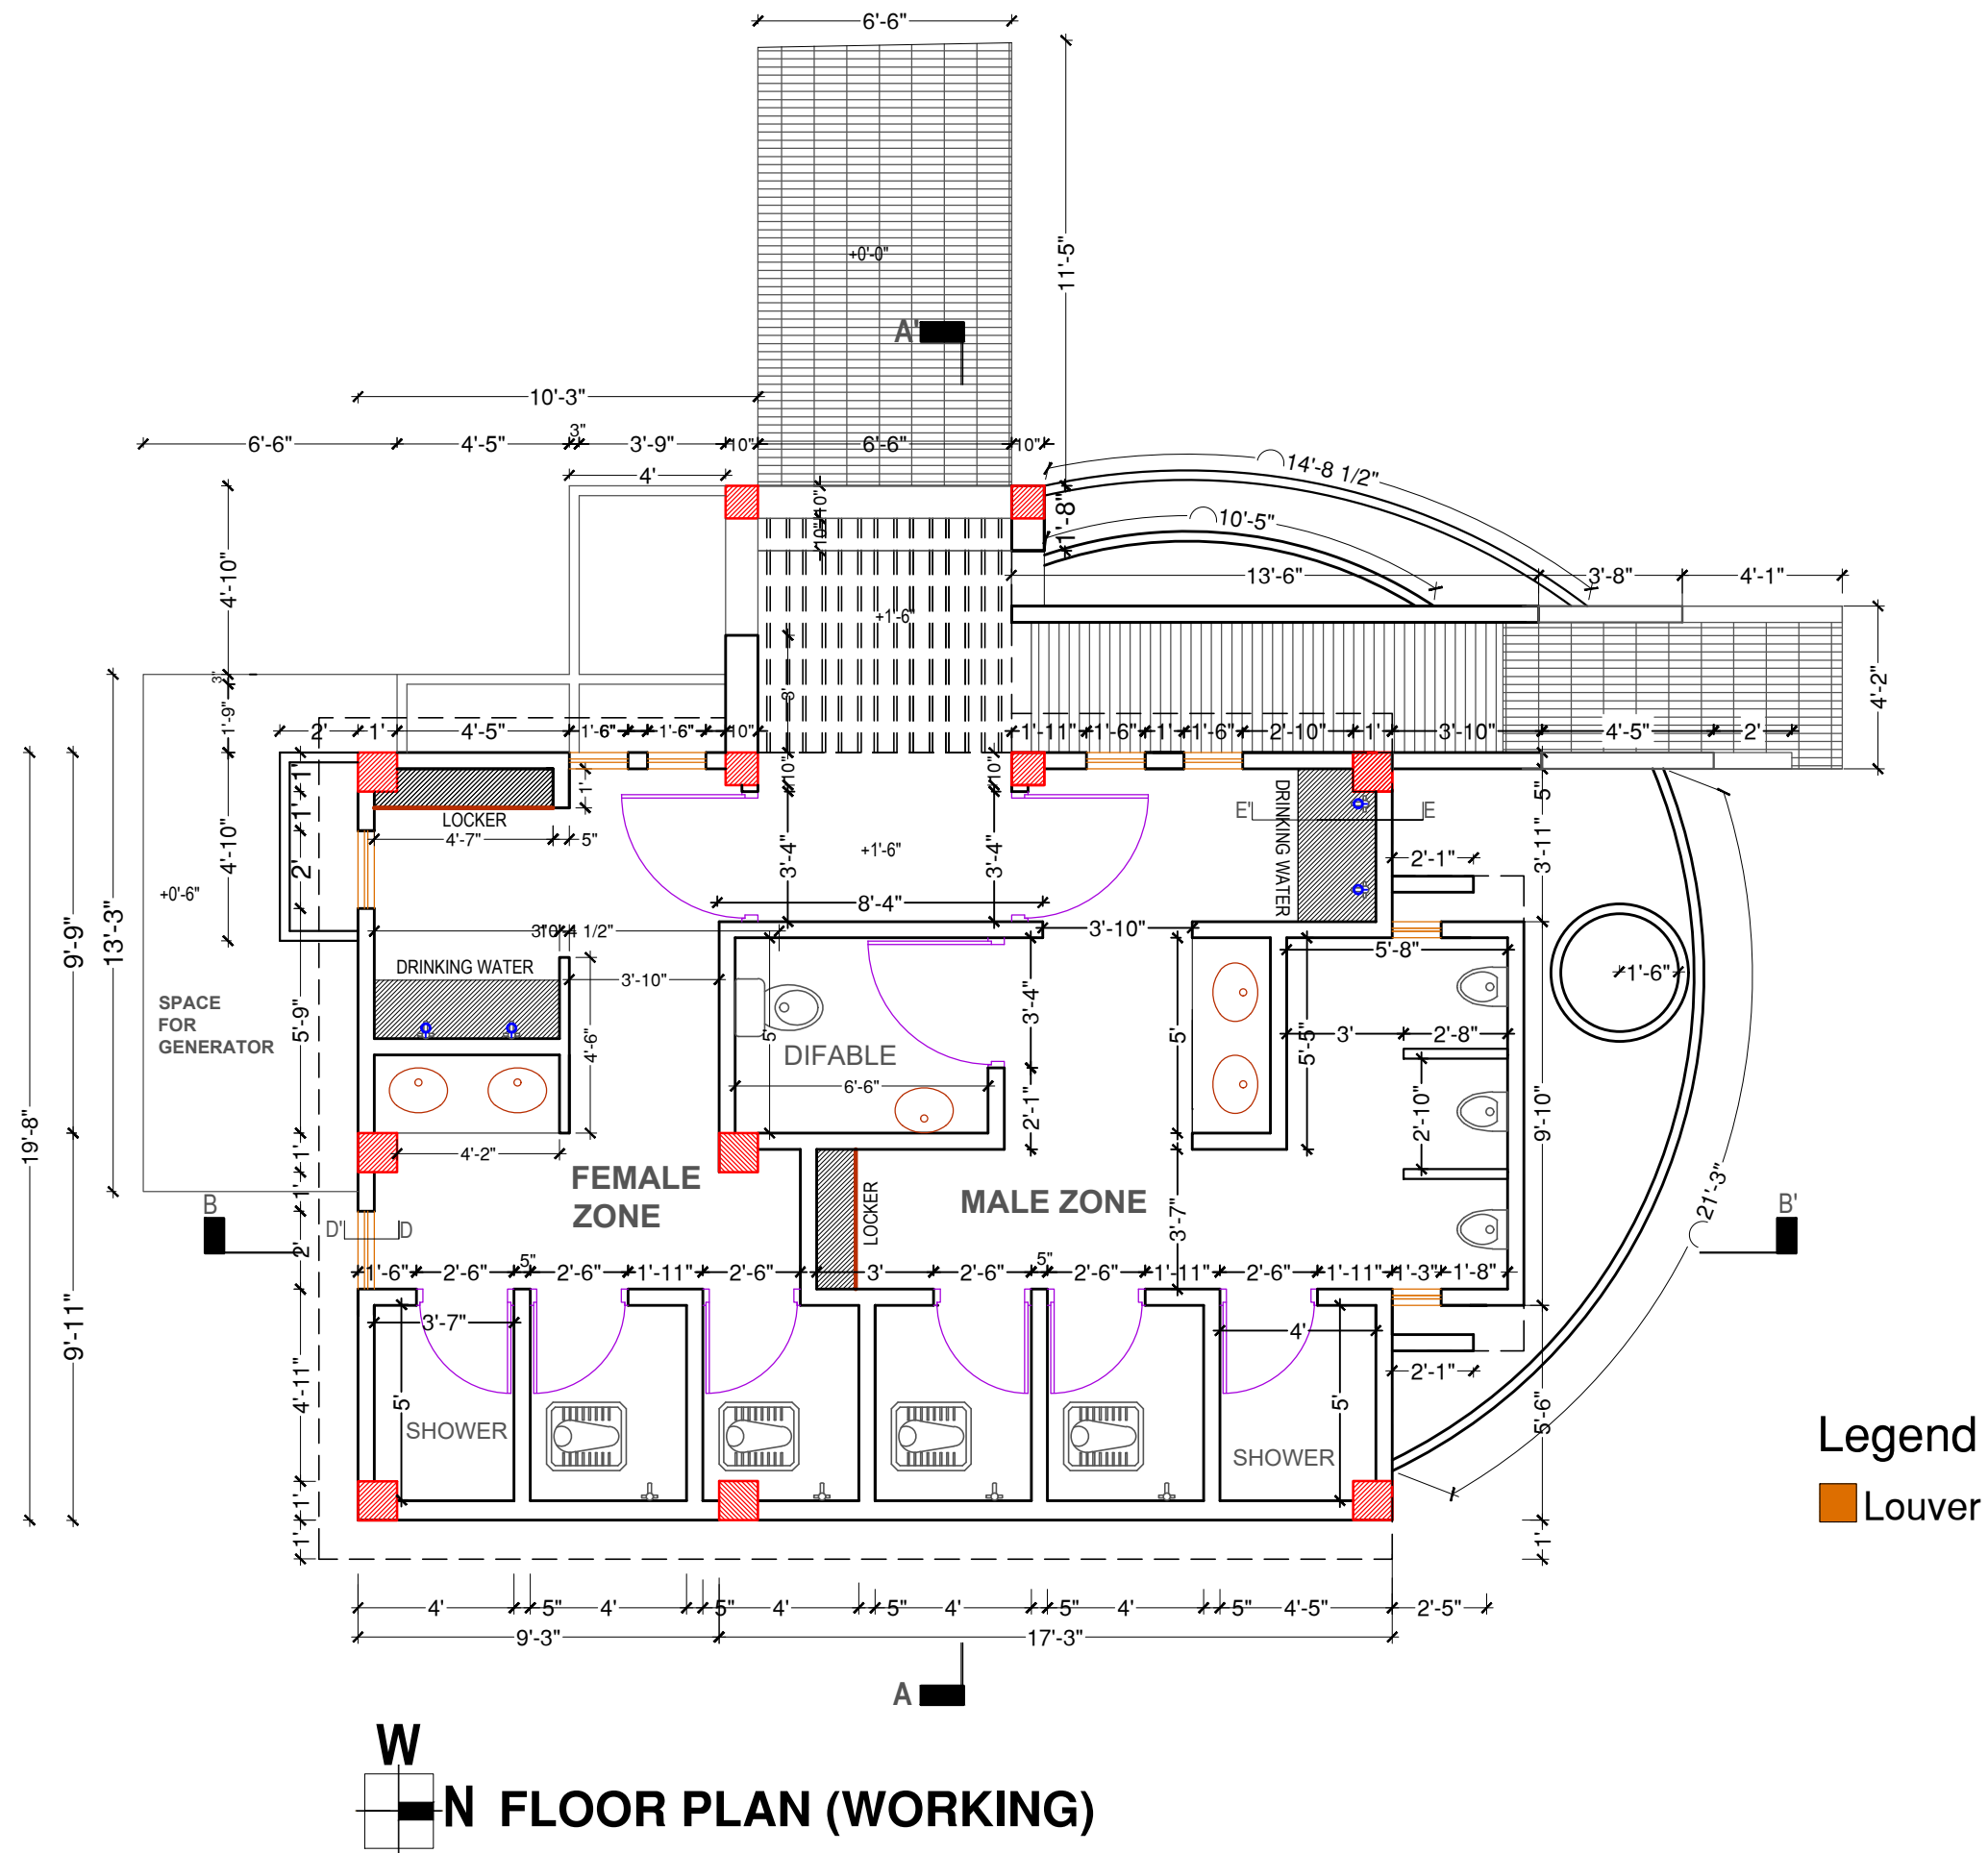

Project
Proposed Design of Public Toilet
at Oxygen more, Chittagong

Project Location
Chittagong

Client
DSK
WATER AID

Drawing Title
FLOOR PLAN (WORKING)

Scale
1' 1' 2' 4' 8'

Date
03.02.2018

Drawing Number
A-5

Drawing Option

Design Team

Architect
Ashraful Alum
B. Arch, BUET
Fahmida Haque
B. Arch, BUET
Md. Tanvir Hossain Chowdhury
B. Arch, SUB
Samanta Safrina Zahir
B. Arch, AUST

Engineer


Md. Moshir Rahman
B.Sc. Civil, UAP
Md. Fuhad Mollah
B.Sc. Civil, UITS

Consultant

IDYLLIC DESIGN



Flat- F3(2ndFloor), Raja Villa, 113 Lake
Circus, Dhaka-1205, Bangladesh
Phone : 9611397-8, 01713044077
email : idyllicdesign11@gmail.com

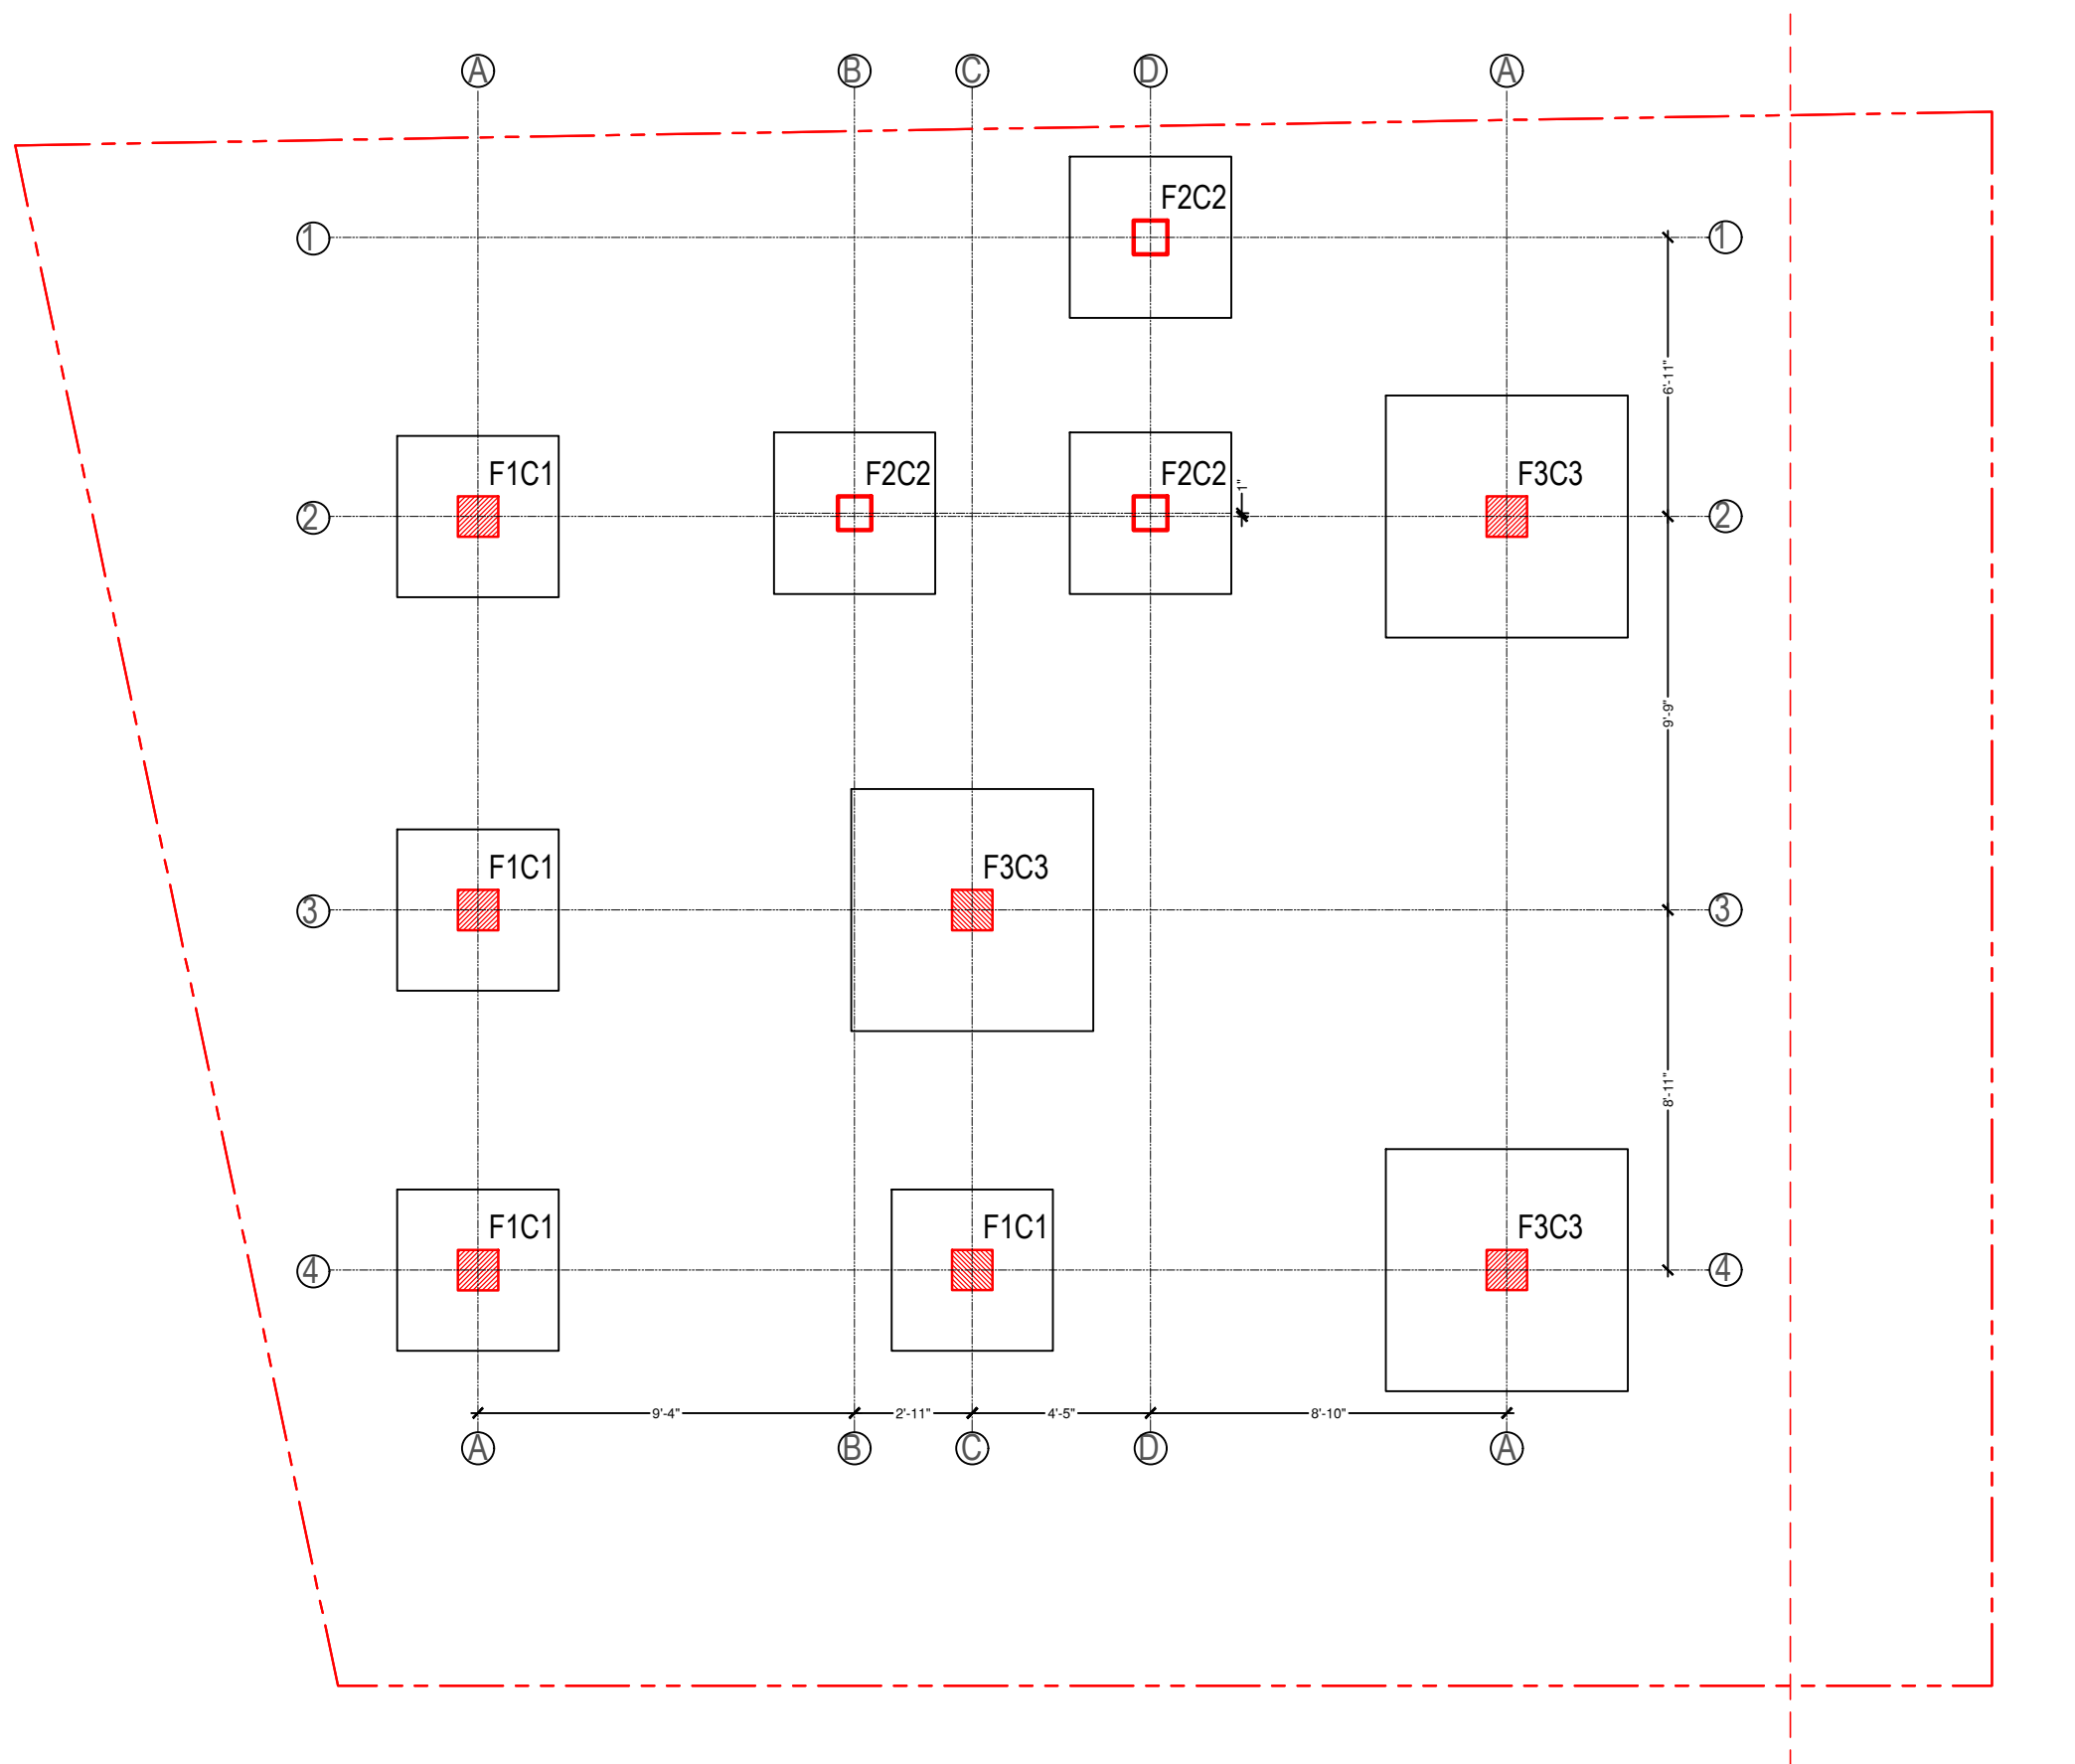

W
N Foundation Layout Plan

Project
Proposed Design of Public Toilet
at Oxygen more, Chittagong

Project Location
Chittagong

Client
DSK
WATER AID

Drawing Title
Foundation Layout Plan

Scale
1' 1' 2' 4' 8'

Date
03.02.2018

Drawing Number
C-3

Drawing Option


Design Team
Architect
Ashraful Alum
B. Arch, BUET
Fahmida Haque
B. Arch, BUET
Md. Tanvir Hossain Chowdhury
B. Arch, SUB

Engineer
Md. Moshir Rahman
B.Sc. Civil, UAP
Md. Fuhad Mollah
B.Sc. Civil, UITs


Consultant
IDYLLIC DESIGN




Flat- F3(2ndFloor), Raja Villa, 113 Lake
Circus, Dhaka-1205, Bangladesh
Phone : 9611397-8, 01713044077
email : idyllicdesign11@gmail.com

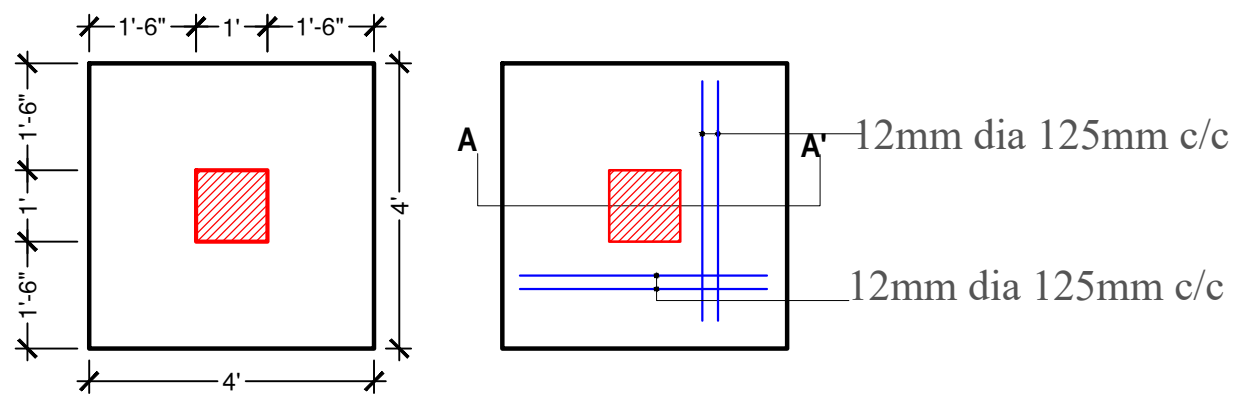


F1C1 PLAN

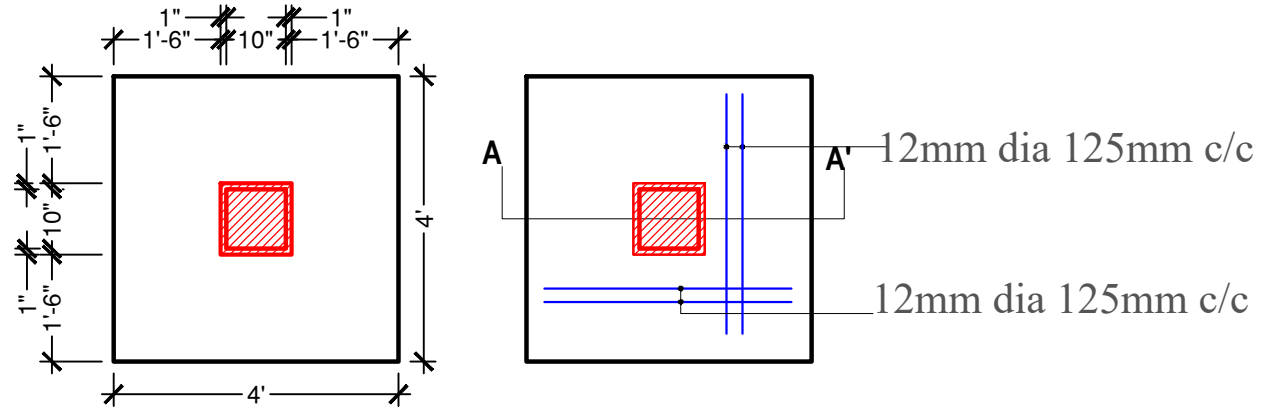

F2C2 PLAN

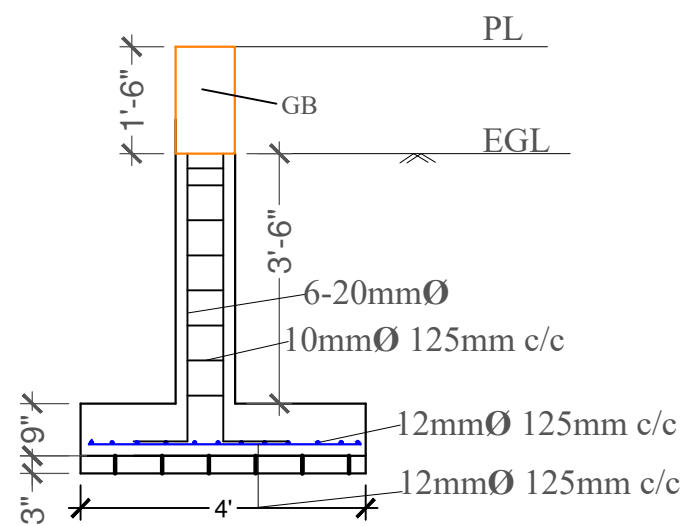

Section A-A'

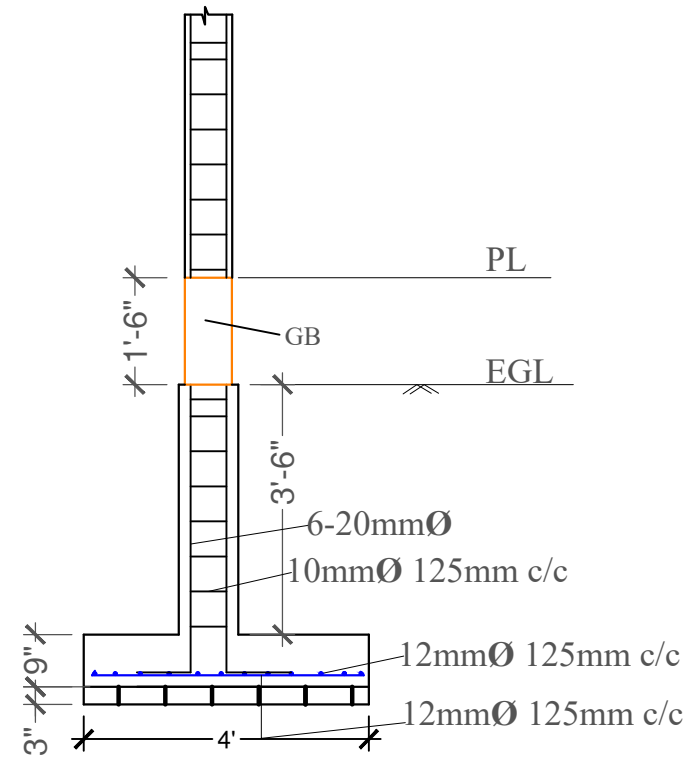

Section A-A'

 
Project
Proposed Design of Public Toilet
at Oxygen more, Chittagong

Project Location
Chittagong

Client
DSK
WATER AID

Drawing Title

Foundation Details



Date
03.02.2018

Drawing Number
C-4

Drawing Option

Design Team

Architect
Ashraful Alum
B. Arch, BUET
Fahmida Haque
B. Arch, BUET
Md. Tanvir Hossain Chowdhury
B. Arch, SUB

Engineer


Md. Moshir Rahman
B.Sc. Civil, UAP
Md.Fuhad Mollah
B.Sc. Civil, UIT

Consultant




IDYLLIC DESIGN



Flat- F3(2ndFloor), Raja Villa, 113 Lake
Circus, Dhaka-1205,Bangladesh
Phone : 9611397-8, 01713044077
email : idyllicdesign11@gmail.com

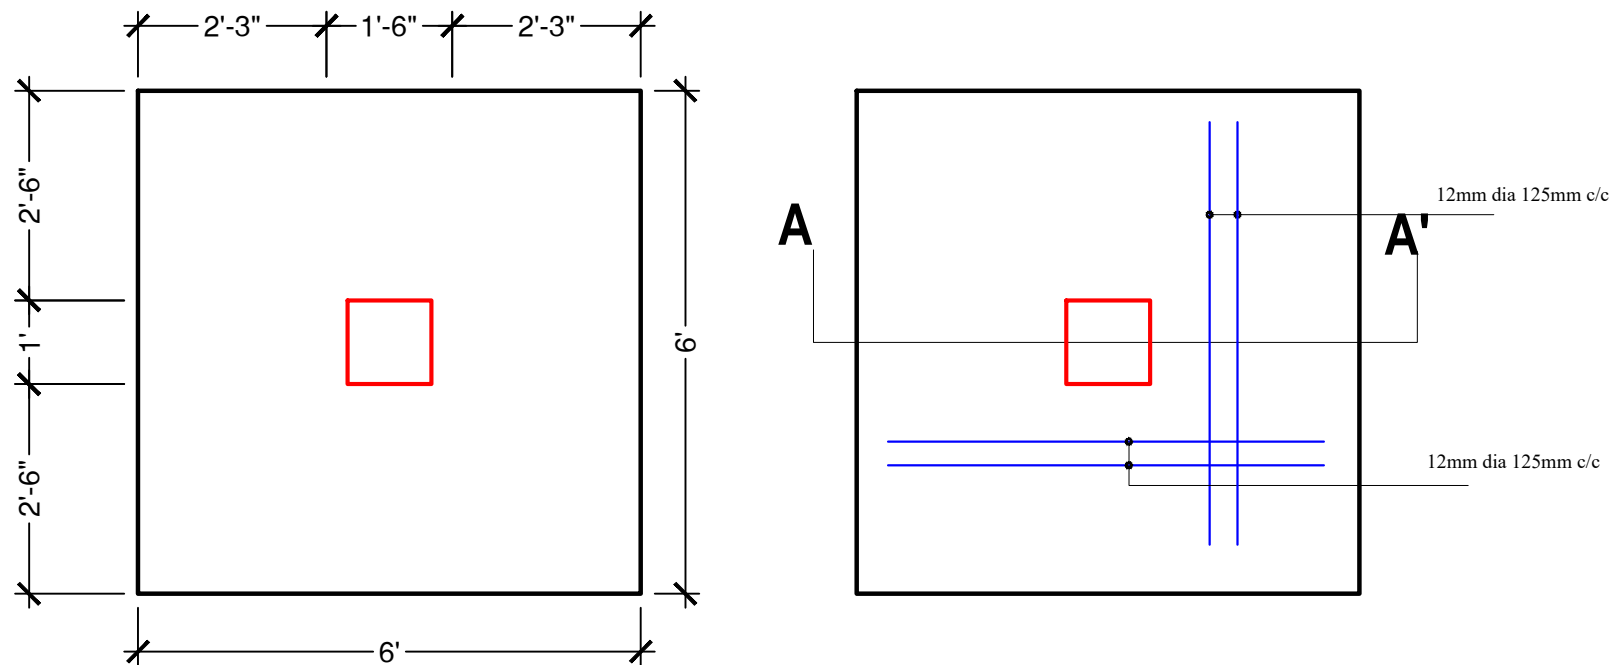

F3C3 PLAN

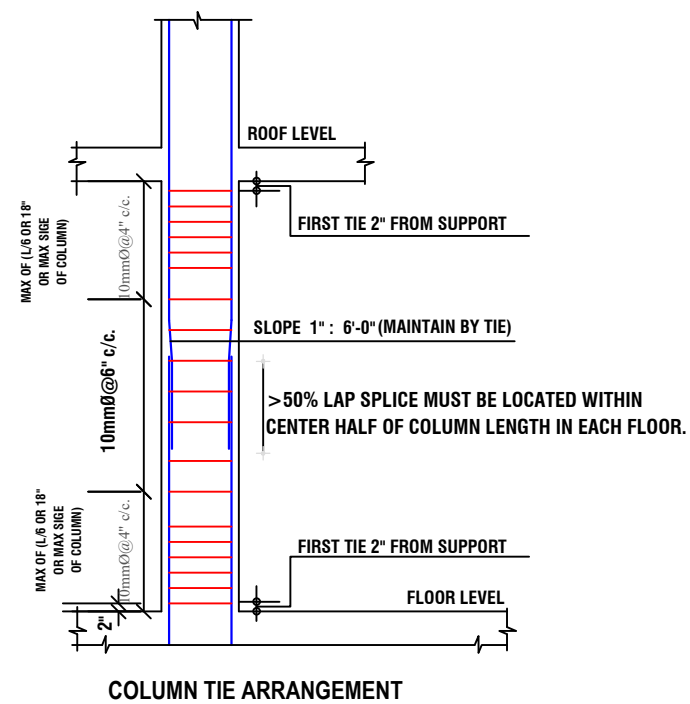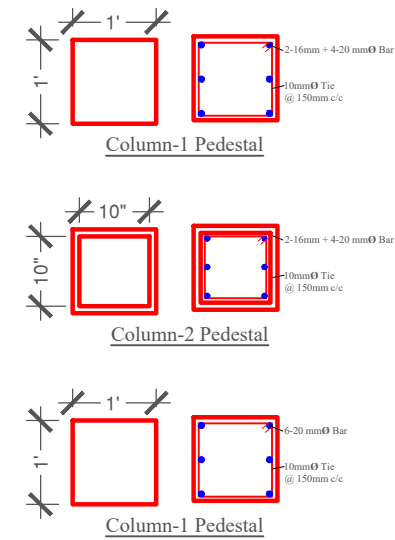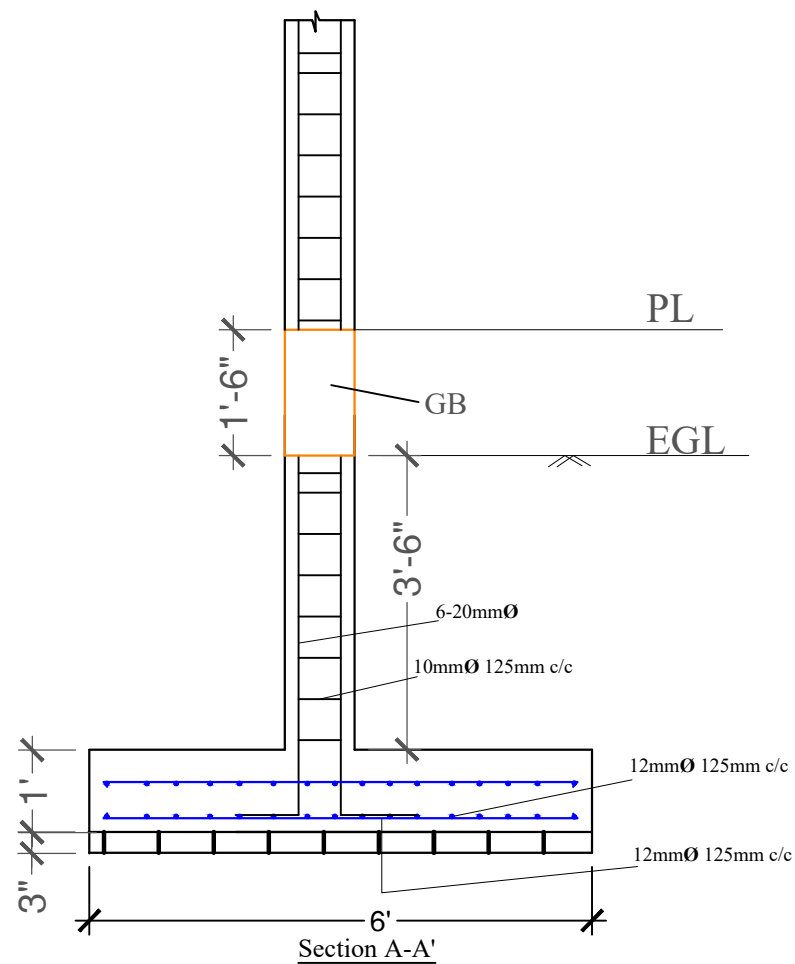

Project
Proposed Design of Public Toilet
at Oxygen more, Chittagong

Project Location
Chittagong

Client
DSK
WATER AID

Drawing Title
Foundation & Column Details

Scale
1' 1' 2' 4' 8'

Date
03.02.2018

Drawing Number
C-5

Drawing Option


Design Team
Architect
Ashraful Alum
B. Arch. BUET
Fahmida Haque
B. Arch. BUET
Md. Tanvir Hossain Chowdhury
B. Arch. SUB

Engineer
Md. Moshir Rahman
B.Sc. Civil, UAP
Md.Fuhad Mollah
B.Sc. Civil, UITS

Consultant
IDYLLIC DESIGN



Flat- F3(2ndFloor), Raja Villa, 113 Lake
Circus, Dhaka-1205,Bangladesh
Phone : 9611397-8, 01713044077
email : idyllicdesign11@gmail.com

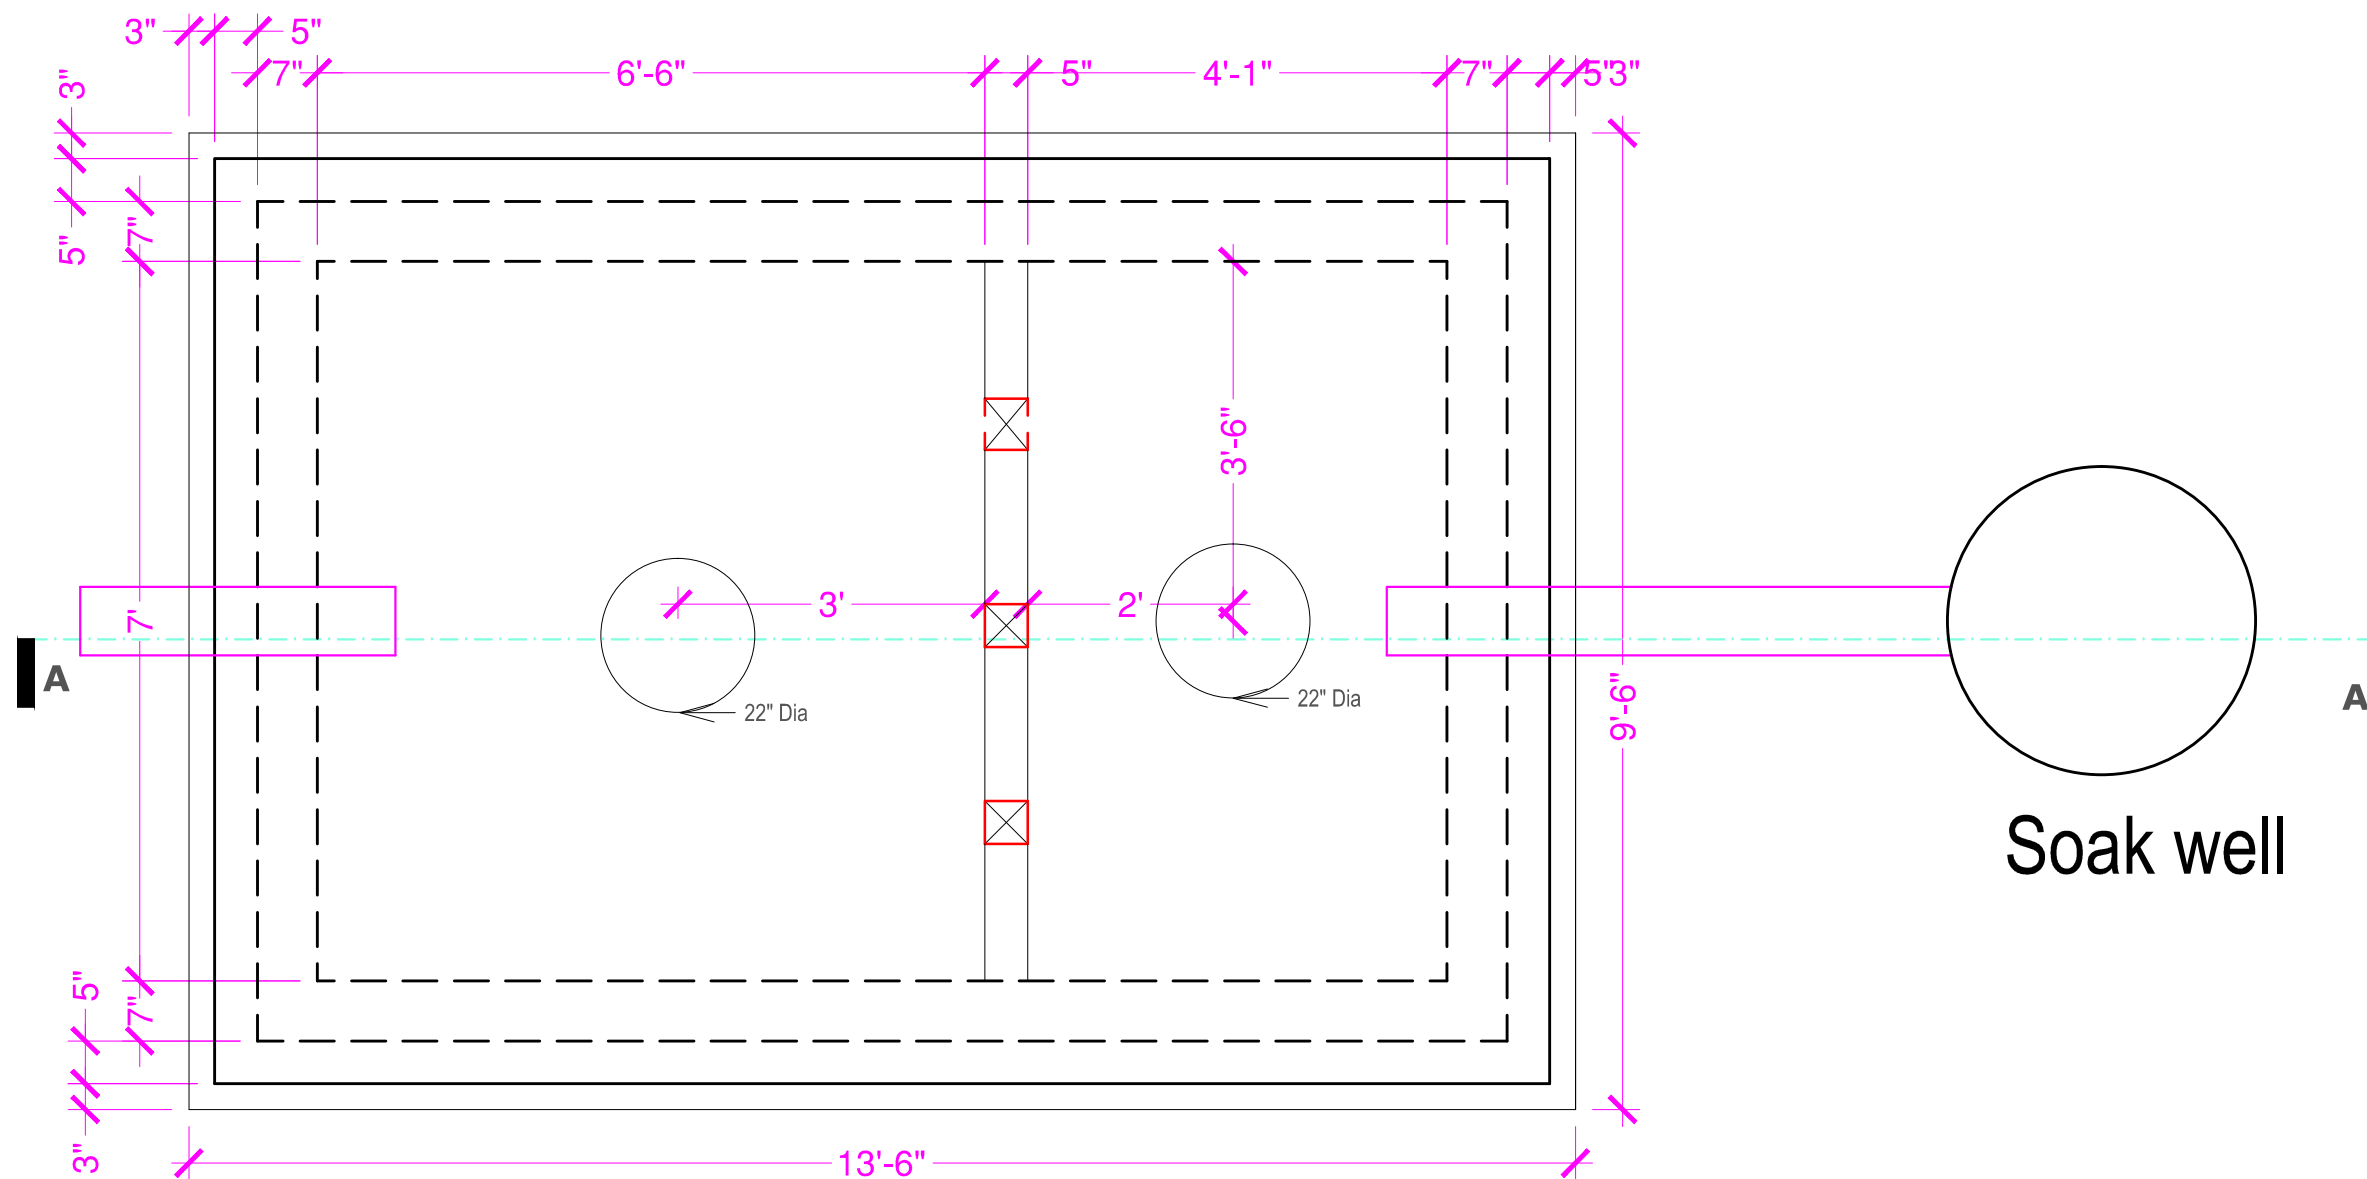

SEPTIC TANK DETAILS

Project
Proposed Design of Public Toilet
at Oxygen more, Chittagong

Project Location
Chittagong

Client
DSK
WATER AID

Drawing Title
SEPTIC TANK DETAILS

Scale
1' 1' 2' 4' 8'

Date
03.02.2018

Drawing Number
ST-2

Drawing Option
OPTION 2

Design Team
Architect
Ashrafal Alum
B. Arch, BUET
Fahmida Haque
B. Arch, BUET
Md. Tanvir Hossain Chowdhury
B. Arch, SUB

Engineer
Noor Mohammad
B.Sc. Engr Electrical
MIEB-23539
Sadequul Islam
B.Sc. Engr Mechanical
MIEB-24575
Md. Moshir Rahman
B.Sc. Civil, UAP

Consultant
IDYLLIC DESIGN



Flat- F3(2ndFloor), Raja Villa, 113 Lake
Circus, Dhaka-1205, Bangladesh
Phone : 9611397-8, 01713044077
email : idyllicdesign11@gmail.com