

NOTE
1. LEVEL :
G.F±0 = GL+1,000
GL±0 = F.H+0,000
2. BOUNDARY WALL : REFER TO A-1001-1002

△					
△					
△	2013.10.16				
△	DATE	DESCRIPTION	DRW	CHK	APP

DRAWING TITLE
SITE PLAN

APPROVED: Jeong, Young Kyoan

CHECKER1: Kwon, Gi Jae

CHECKER2: Choi, Jae Young


 
DRW: Oh, Bich Na

PROJECT NO.: DC2013000006

SCALE	APPROVAL DATE
A1	
1/200	2013. 10.
A3	
1/400	

DRAWING NO.: A-101

1 SITE PLAN
SCALE: A1 1/200
A3 1/400

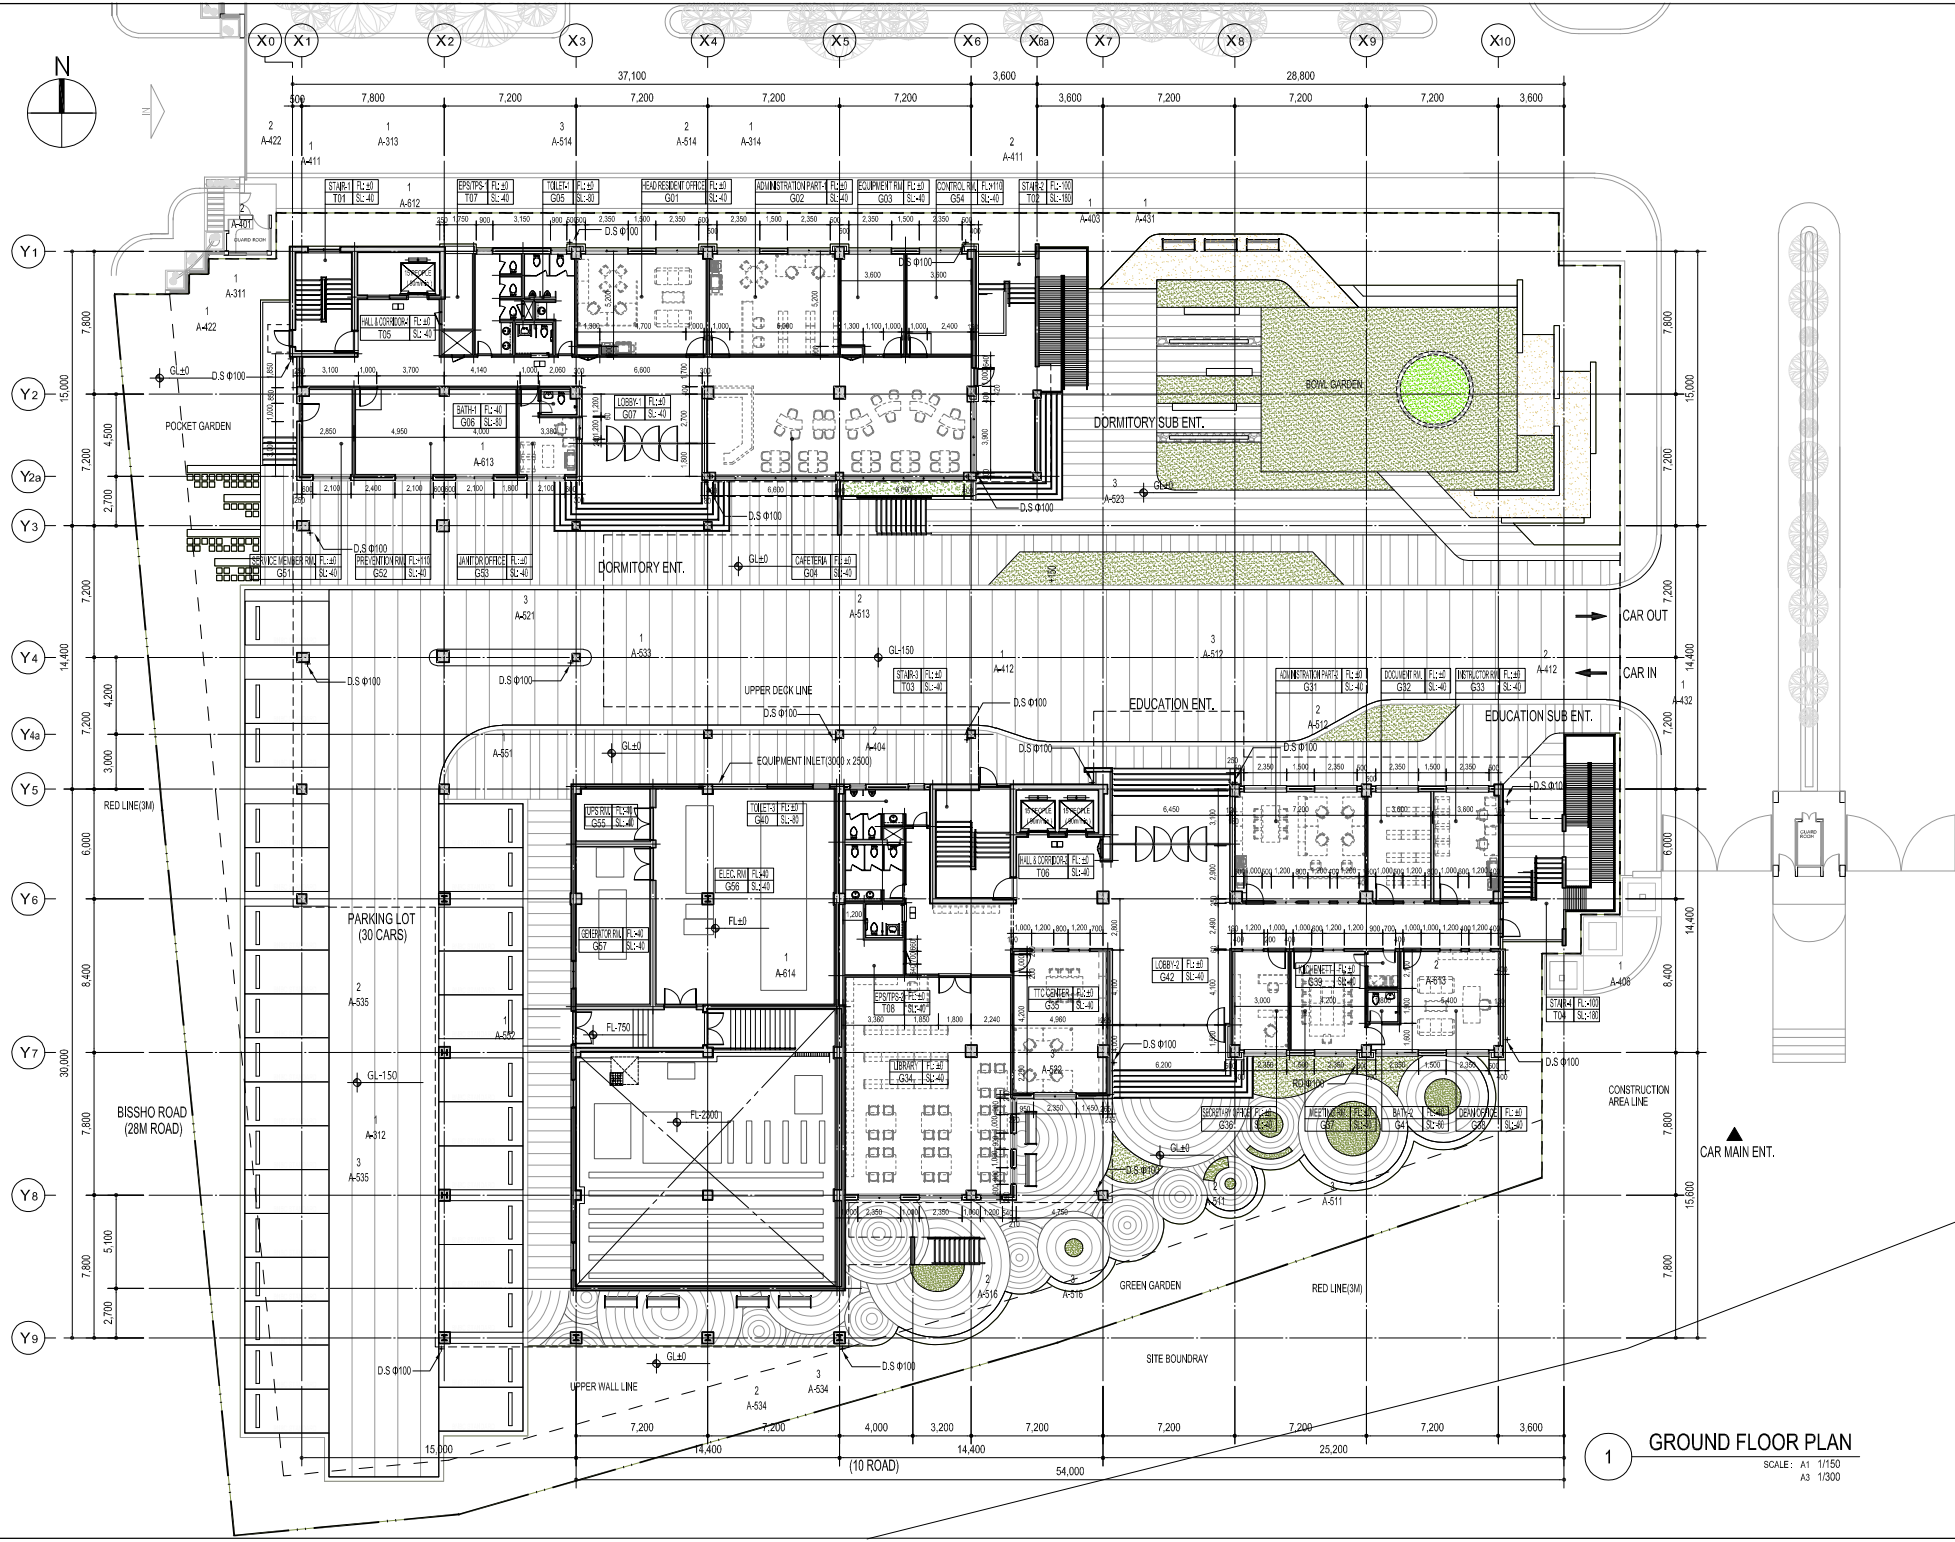

DATE	DESCRIPTION	ERM	CHK	APP


GROUND FLOOR PLAN

APPROVED: Jeong, Young Kyoan
CHECKED: Kwon, Gi Jae
CHECKED: Choi, Jae Young
DRAWN: Oh, Jong Su

PROJECT NO.: DC2013000006

SCALE	APPROVAL DATE
A1	
1/150	1/300
	2013. 10.

1 GROUND FLOOR PLAN
SCALE: A1 1/150
A3 1/300

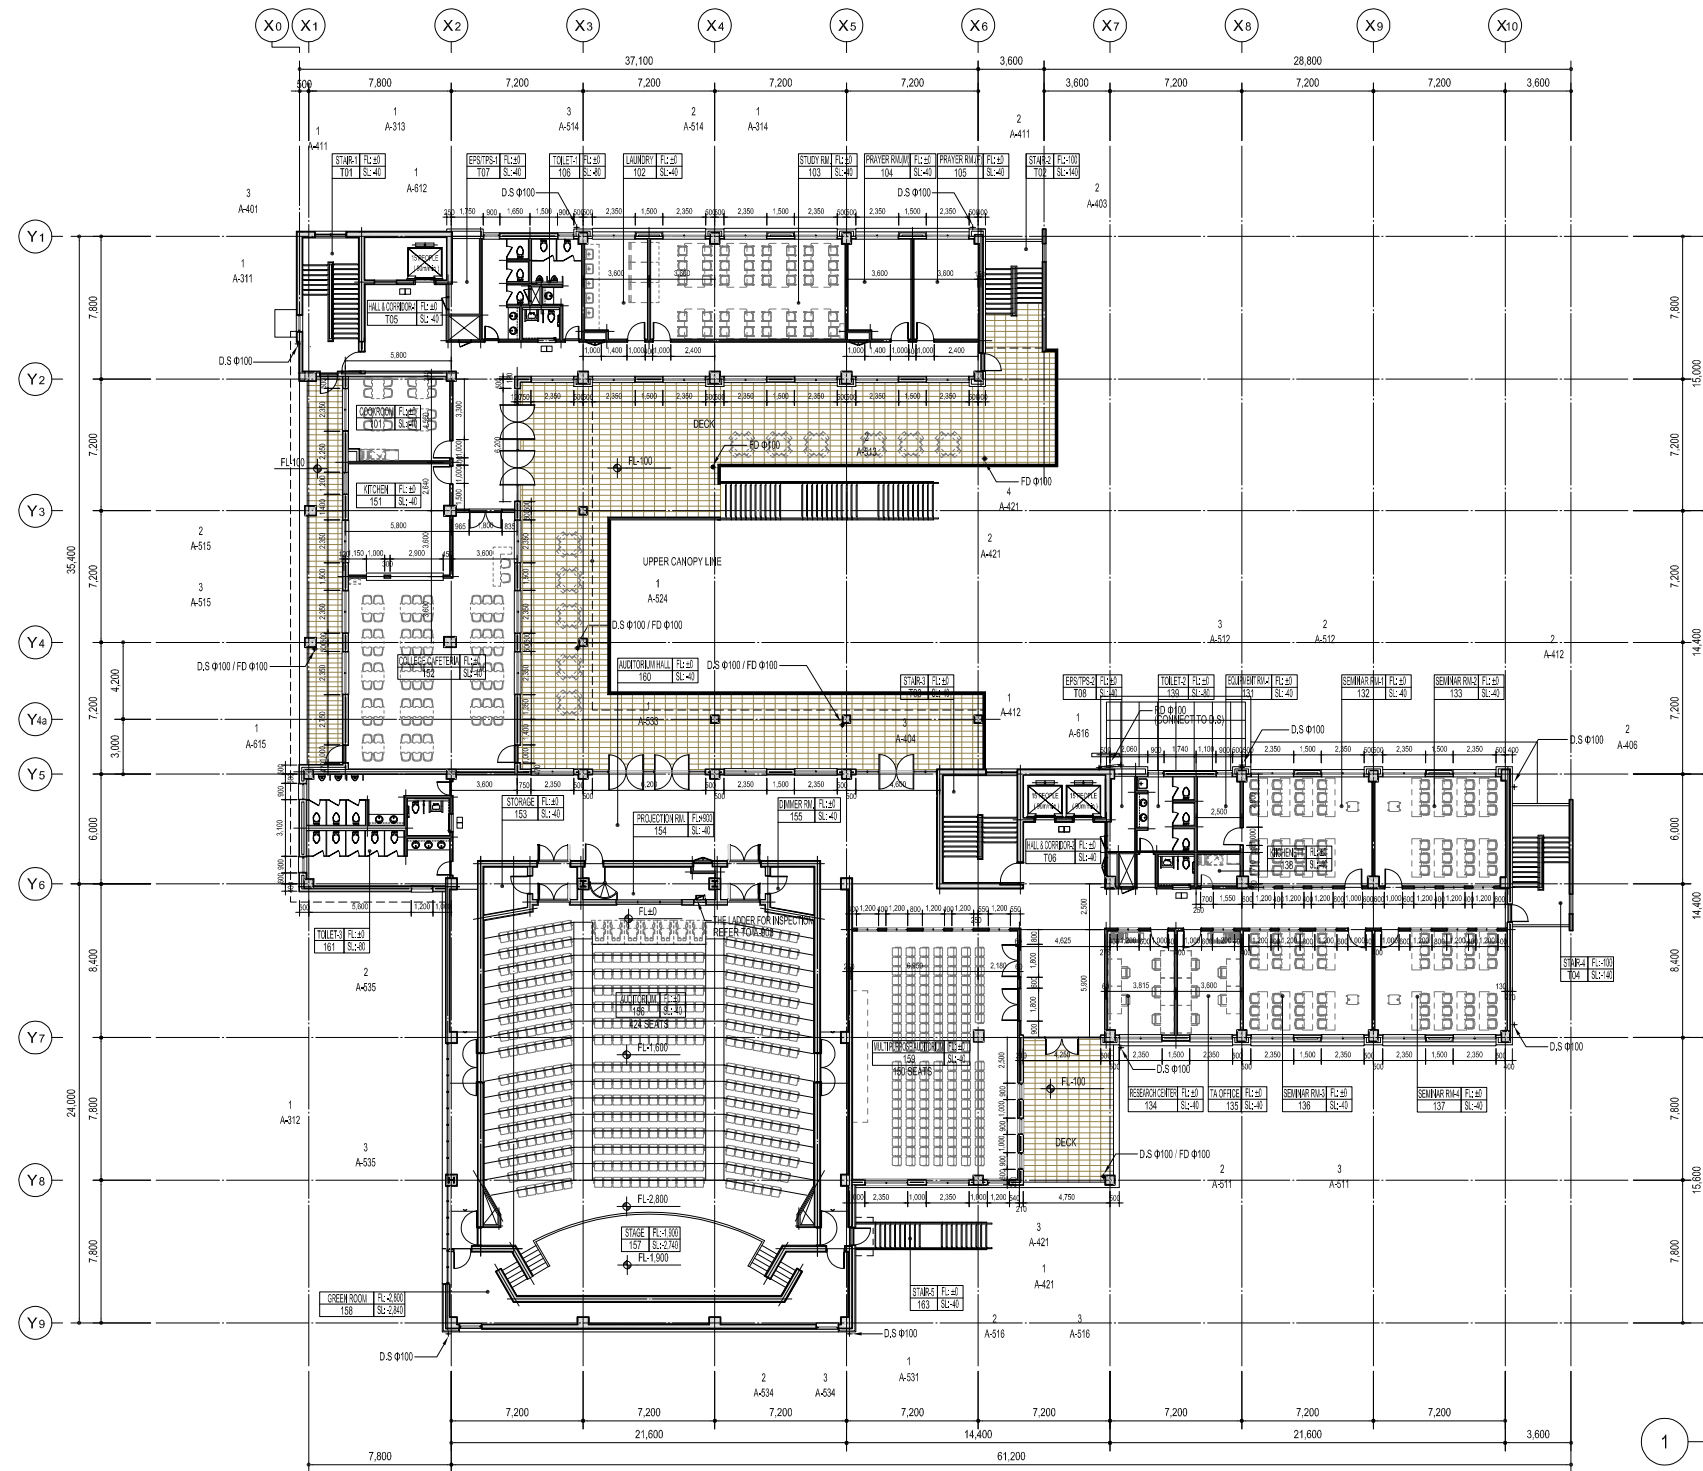

1 1ST FLOOR PLAN
SCALE: A1 1/150
A3 1/300

PROJECT TITLE
Establishment of National Institute of
Advanced Practice Nurses Bangladesh

ARCHITECTS
heerim
Architects & Planners
TEL: 02-398-0000 FAX: 02-398-0001

STRUCTURAL CONSULTANTS
MIDAS IT
미디스아이티

MECHANICAL CONSULTANTS
yungdo
YOUNGDO ENGINEERS & CONSULTANTS

ELECTRICAL CONSULTANTS
대일인원기술(주)
DAEIL ENGINEERING & CONSTRUCTION CO., LTD.

GENERAL CONTRACTOR
Jin Young
Consultants Co., Ltd.

LANDSCAPE DESIGNERS
heerim
Architects & Planners

APPROVED BY
CHIEF ARCHITECT,
DEPARTMENT OF ARCHITECTURE
MD. AHASANUL HAQUE KHAN (SWAPAN)

KEY MAP

NOTE
1. LEVEL
IF F.L. = GL + 6.100
2. RD & FD & D.S. REFER TO A-907

△					
△					
△	2013.03.27				
DATE	DESCRIPTION	ERM	CHK	APP	

DRAWING TITLE 1st FLOOR PLAN					
APPROVED	Jeong, Young Kyoong				
CHECKED	Kwon, Gi Jae				
CHECKED	Choi, Jae Young				
DRAWN	Oh, Jong Su				
PROJECT NO.	DC2013000006				
SCALE	APPROVAL DATE				
A1	A3				
1/150	1/300	2013. 10.			
DRAWING NO.	A-223				REV.

PROJECT TITLE
Establishment of National Institute of
Advanced Practice Nurses Bangladesh

ARCHITECTS
heerim
Architects & Planners
TEL: 82-2-3400-1111 FAX: 82-2-3400-1113

STRUCTURAL CONSULTANTS
MIDAS IT
미디스아이티

MECHANICAL CONSULTANTS
yungdo
YOUNGDO ENGINEERS & CONSULTANTS

ELECTRICAL CONSULTANTS
대림이엔씨기술(주)
DAE RIM ENGINEERING & CONSTRUCTION CO., LTD.

GENERAL CONTRACTOR
Jin Young
Consultants Co., Ltd.

LANDSCAPE DESIGNERS
heerim
Architects & Planners

APPROVED BY
CHIEF ARCHITECT,
DEPARTMENT OF ARCHITECTURE
MD. AHASANUL HAQUE KHAN (SWAPAN)

KEY MAP

- NOTE
1. LEVEL
2F FL±0 = GL+10.600
 2. ALL DORMITORY UNIT RM, TOILET SL-40
 3. RD & FD & D.S REFER TO A-907
 4. UNIT BATH FL-40

△					
△					
△					
DATE	DESCRIPTION	DRN	CHK	APP	

DRAWING TITLE
2nd FLOOR PLAN

APPROVED: Jeong, Young Kyoan

CHECKED BY: Kwon, Gi Jae


CHECKED BY: Choi, Jae Young

DRAWN: Oh, Jong Su


PROJECT NO.: DC2013000006

SCALE	APPROVAL DATE
A1	
1/150	1/300
	2013. 10.

DRAWING NO. A-224

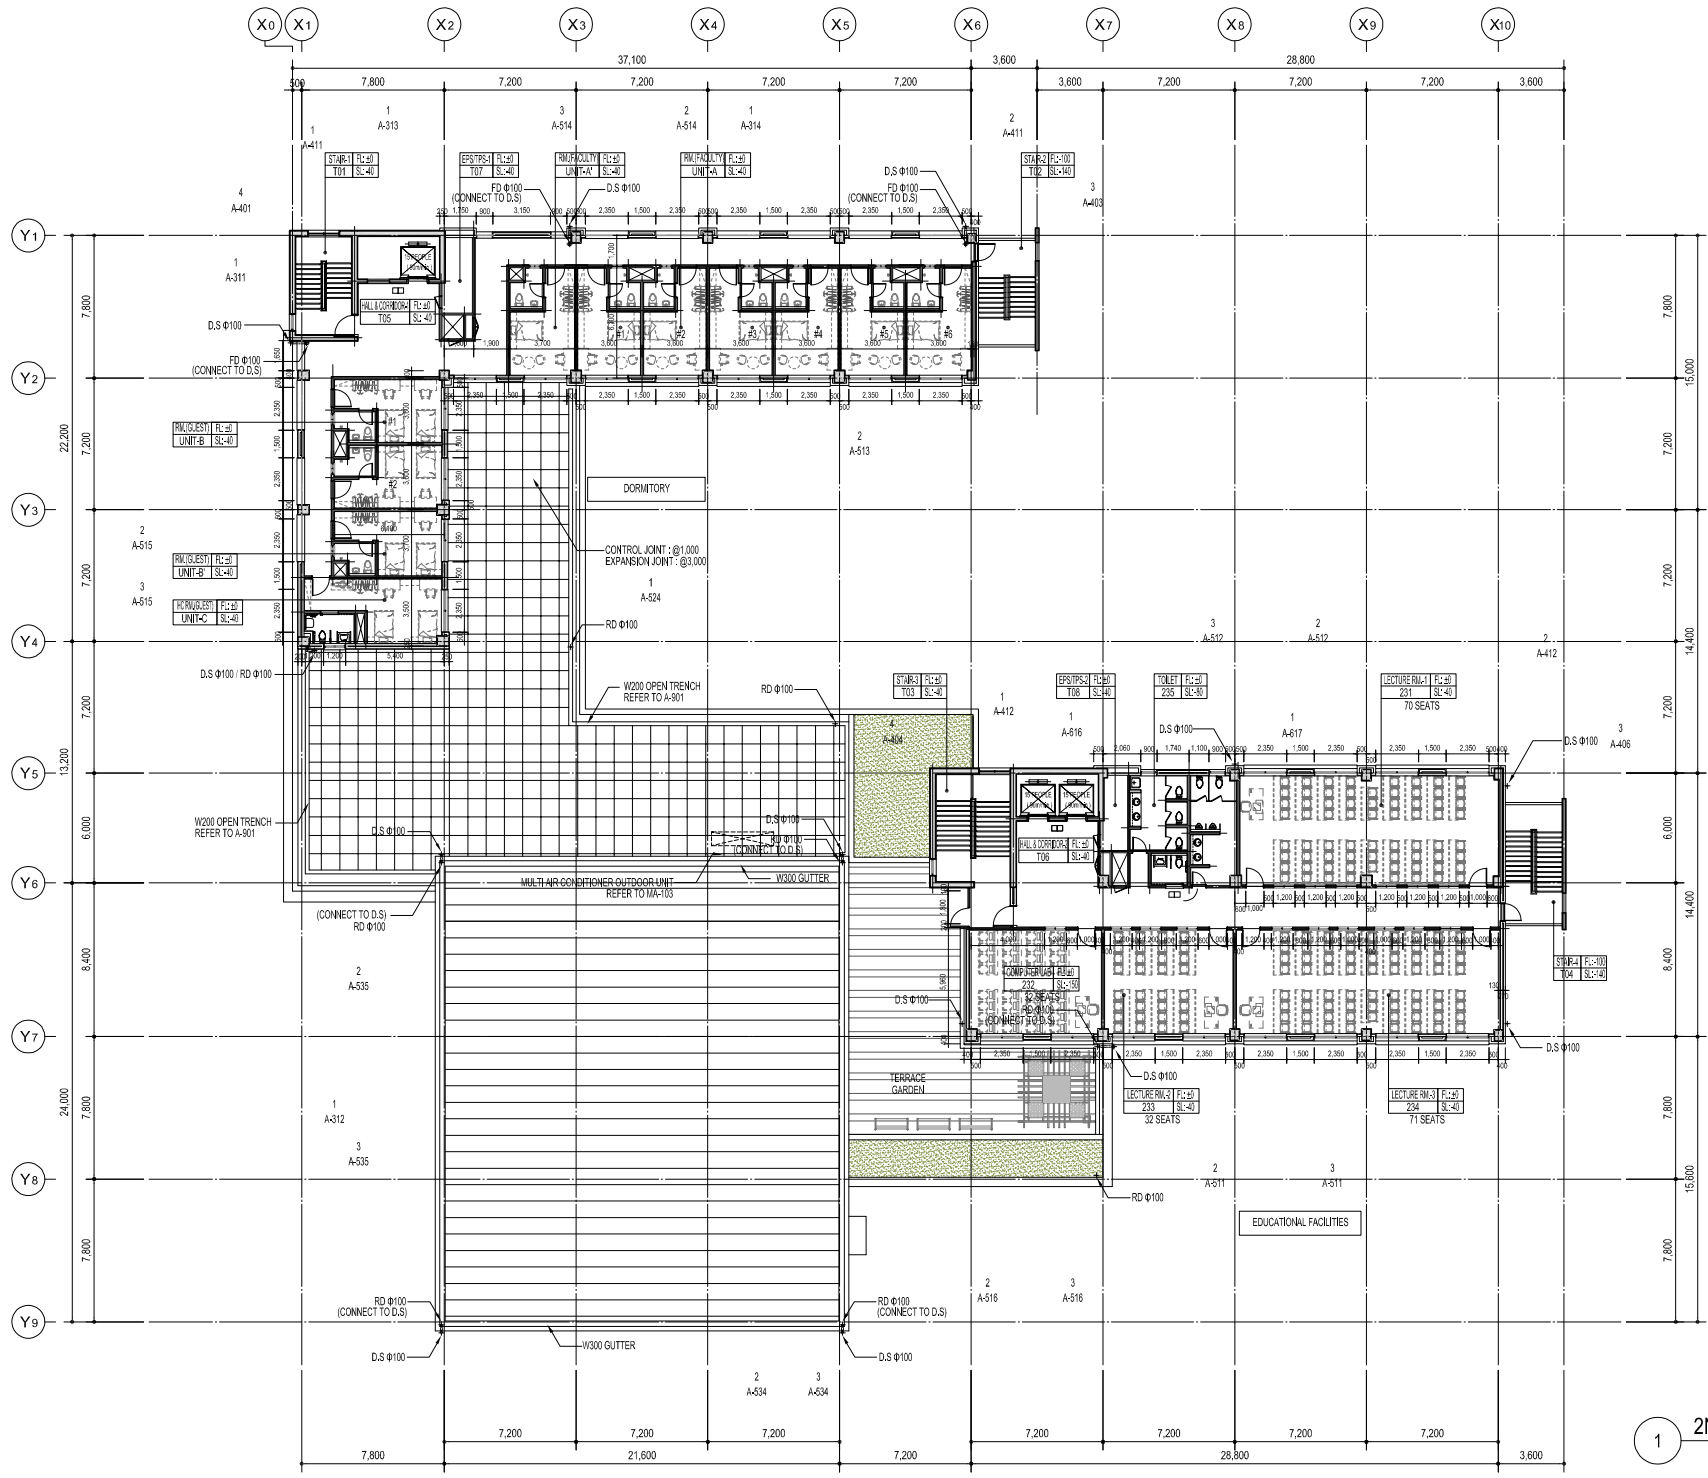

1 2ND FLOOR PLAN
SCALE: A1 1/150
A3 1/300

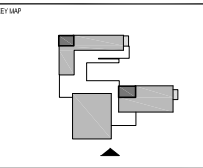

- NOTE
- FACE BRICK
TYPE-A: RED BRICK (EDUCATIONAL FACILITIES)
TYPE-B: LIGHT RED BRICK (DORMITORY)
 - TILES
TYPE-A: BEIGE 200X300
TYPE-B: GRAY 600X600
TYPE-C: GRAY 600X300
TYPE-D: BEIGE 600X600
 - EMULSION PAINT
TYPE-A: WHITE COLOR
TYPE-B: DARK GRAY
TYPE-C: LIGHT GRAY

△					
△					
△	2013.				
△	DATE	DESCRIPTION	DRN	CHK	APP

DRAWING TITLE
SOUTH ELEVATION - 1


APPROVED	Jeong, Young Kyoan
CHECKED	Kwon, Gi Jae
CHECKED	Choi, Jae Young
DRAWN	Jung, Se Young

PROJECT NO.: DC2013000006

SCALE	APPROVAL DATE
A1	
1/150	1/300
	2013. 10.

DRAWING NO.	REV.
A-301	

X0 X1 X2 X3 X4 X5 X6 X7 X8 X9 X10

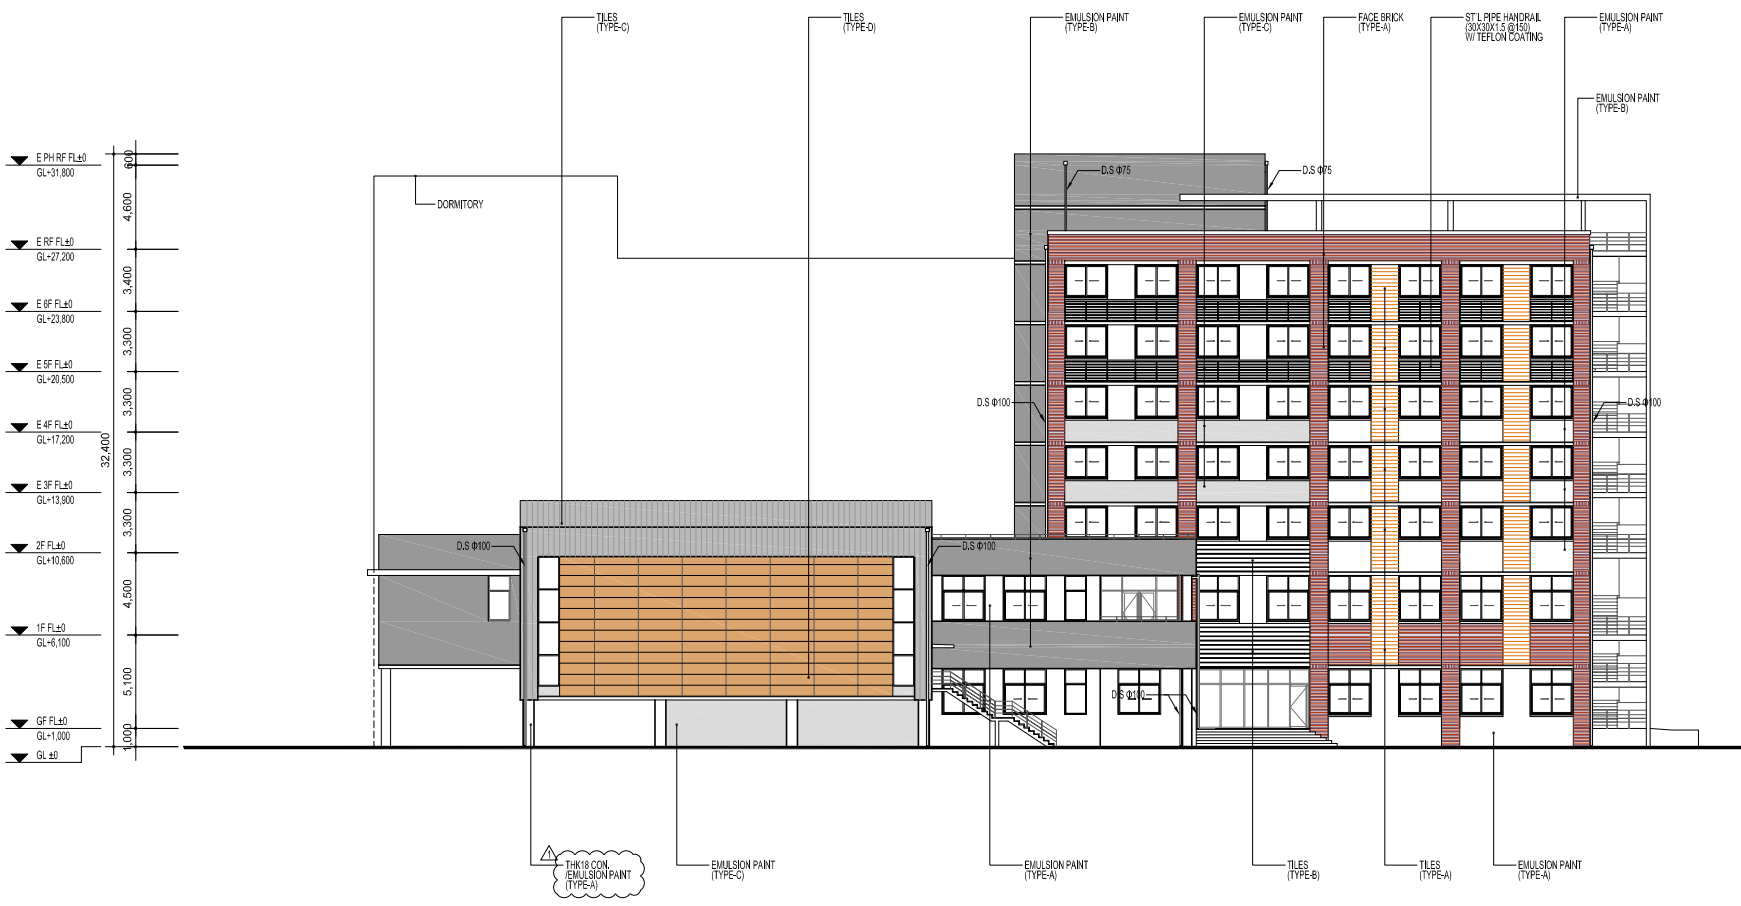

1 SOUTH ELEVATION - 1
SCALE: A1 1/150
A3 1/300



- NOTE
- FACE BRICK
TYPE-A: RED BRICK (EDUCATIONAL FACILITIES)
TYPE-B: LIGHT RED BRICK (DORMITORY)
 - TILES
TYPE-A: BEIGE 200X400
TYPE-B: GRAY 600X600
TYPE-C: GRAY 600X300
TYPE-D: BEIGE 600X600
 - EMULSION PAINT
TYPE-A: WHITE COLOR
TYPE-B: DARK GRAY
TYPE-C: LIGHT GRAY

△					
△					
△	2013.				
△	DATE	DESCRIPTION	DRN	CHK	APP

DRAWING TITLE
SOUTH ELEVATION - 2

APPROVED	Jeong, Young Kyoan	<i>[Signature]</i>
CHECKED	Kwon, Gi Jae	<i>[Signature]</i>
CHECKED	Choi, Jae Young	<i>[Signature]</i>
DRAWN	Jung, Se Young	<i>[Signature]</i>


PROJECT NO.: DC2013000006

SCALE	APPROVAL DATE	
A1	A3	
1/150	1/300	2013. 10.

DRAWING NO.	REV.
A-302	



1 SOUTH ELEVATION - 2
SCALE: A1 1/150
A3 1/300

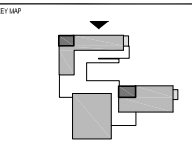

- NOTE
- FACE BRICK
TYPE-A: RED BRICK (EDUCATIONAL FACILITIES)
TYPE-B: LIGHT RED BRICK (DORMITORY)
 - TILES
TYPE-A: BEIGE 200x400
TYPE-B: GRAY 600x600
TYPE-C: GRAY 600x300
TYPE-D: BEIGE 600x600
 - EMULSION PAINT
TYPE-A: WHITE COLOR
TYPE-B: DARK GRAY
TYPE-C: LIGHT GRAY

△				
△				
△				
DATE	DESCRIPTION	DRN	CHK	APP

DRAWING TITLE
NORTH ELEVATION - 1

APPROVED: Jeong, Young Kyoung
CHECKED: Kwon, Gi Jae
CHECKED: Choi, Jae Young
DRAWN: Jung, Se Young


PROJECT NO.: DC2013000006

SCALE	APPROVAL DATE
A1	
1/150	2013. 10.

DRAWING NO.	REV.
A-303	



1 NORTH ELEVATION - 1
SCALE: A1 1/150
A3 1/300

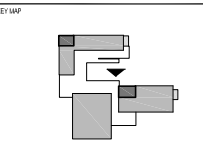

- NOTE
- FACE BRICK
TYPE-A: RED BRICK (EDUCATIONAL FACILITIES)
TYPE-B: LIGHT RED BRICK (DORMITORY)
 - TILES
TYPE-A: BEIGE 200X300
TYPE-B: GRAY 600X600
TYPE-C: GRAY 600X300
TYPE-D: BEIGE 600X600
 - EMULSION PAINT
TYPE-A: WHITE COLOR
TYPE-B: DARK GRAY
TYPE-C: LIGHT GRAY

△					
△	2013.				
△	DATE	DESCRIPTION	DRN	CHK	APP

DRAWING TITLE
NORTH ELEVATION - 2


APPROVED: Jeong, Young Kyoan
CHECKED BY: Kwon, Gi Jae
CHECKED: Choi, Jae Young
DRAWN: Jung, Se Young

PROJECT NO.: DC2013000006

SCALE	APPROVAL DATE
A1	
1/150	1/300
	2013. 10.

DRAWING NO. A-304 REV.

X10 X9 X8 X7 X6 X5 X4 X3 X2 X1

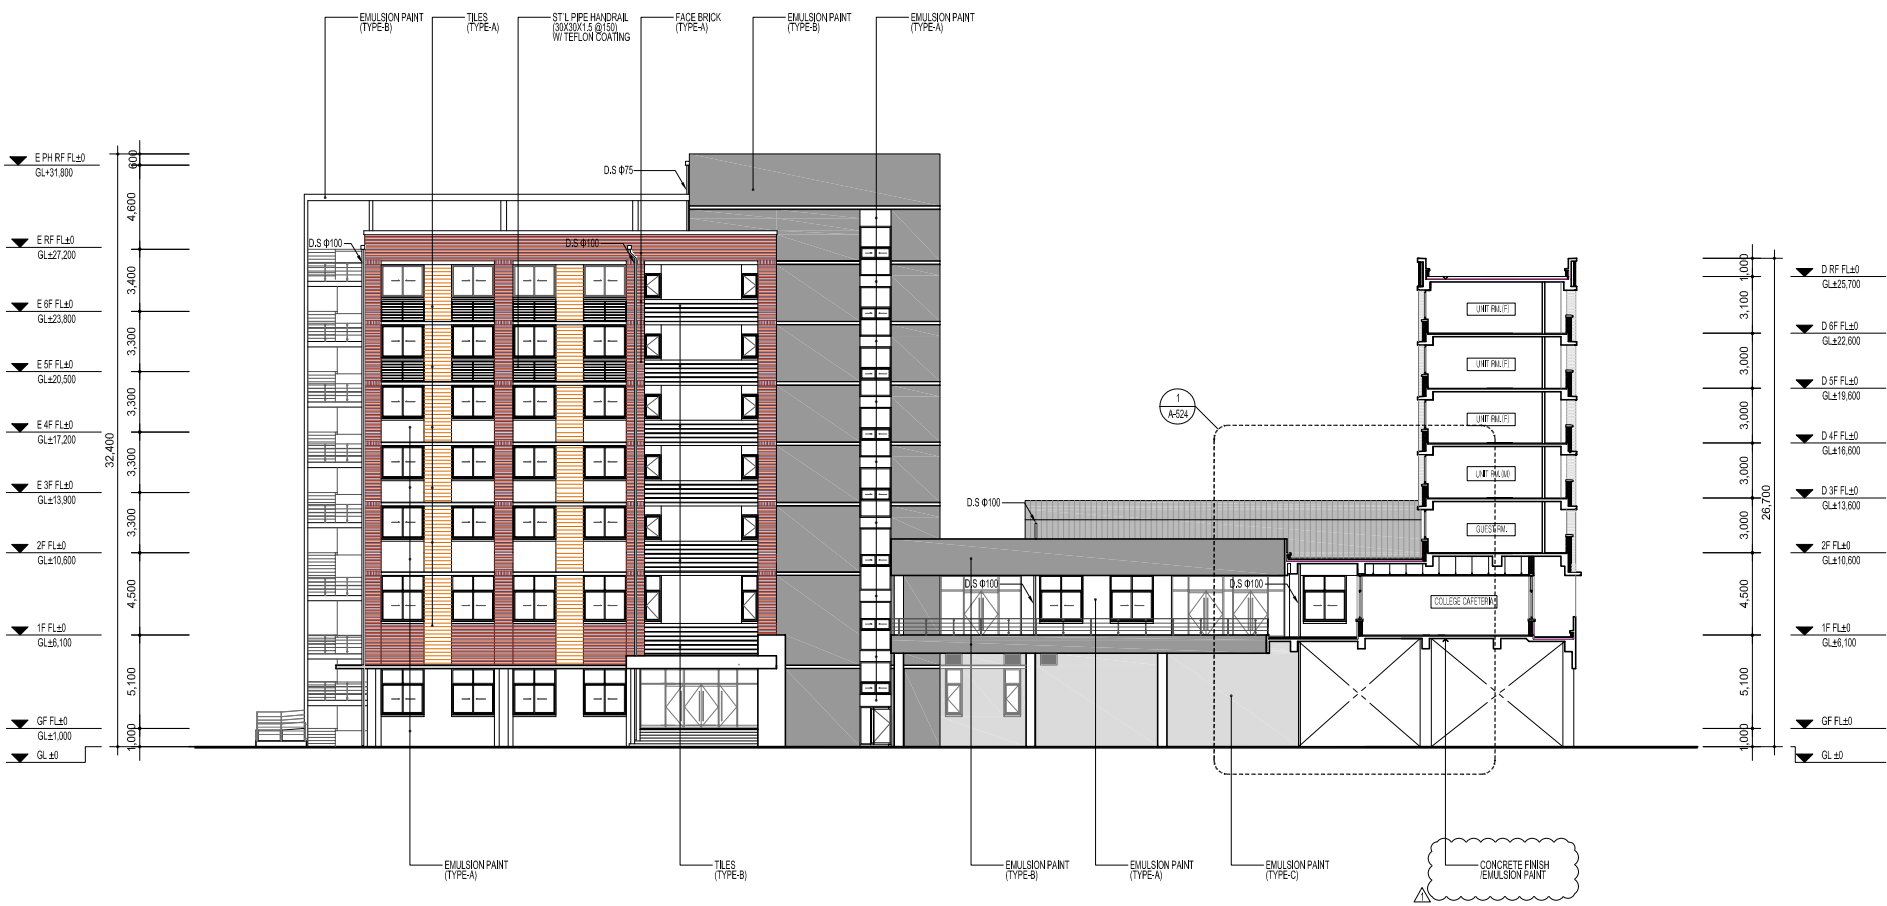

1 NORTH ELEVATION - 2
SCALE: A1 1/150
A3 1/300

PROJECT TITLE
Establishment of National Institute of
Advanced Practice Nurses Bangladesh

ARCHITECTS
heerim
Architects & Planners
TIL, SOO, KIM, PARK, ARCHITECTS

STRUCTURAL CONSULTANTS
MIDAS IT
미디스아이티


MECHANICAL CONSULTANTS
Yungdo
YOUNGDO ENGINEERS & CONSULTANTS

ELECTRICAL CONSULTANTS
대림이엔지니어링(주)
DAE RIM ENGINEERING & CONSTRUCTION CO., LTD.

GENERAL CONTRACTOR
Jin Young
Consultants Co., Ltd.


LANDSCAPE DESIGNERS
heerim
Architects & Planners

APPROVED BY
CHIEF ARCHITECT,
DEPARTMENT OF ARCHITECTURE
MD. AHASANUL HAQUE KHAN (SWAPAN)

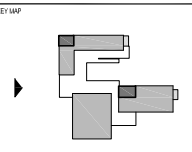

- NOTE
- FACE BRICK
TYPE-A: RED BRICK (EDUCATIONAL FACILITIES)
TYPE-B: LIGHT RED BRICK (DORMITORY)
 - TILES
TYPE-A: BEIGE 600X600
TYPE-B: GRAY 600X600
TYPE-C: GRAY 600X300
TYPE-D: BEIGE 600X600
 - EMULSION PAINT
TYPE-A: WHITE COLOR
TYPE-B: DARK GRAY
TYPE-C: LIGHT GRAY

Y1 Y2 Y3 Y4 Y5 Y6 Y7 Y8 Y9

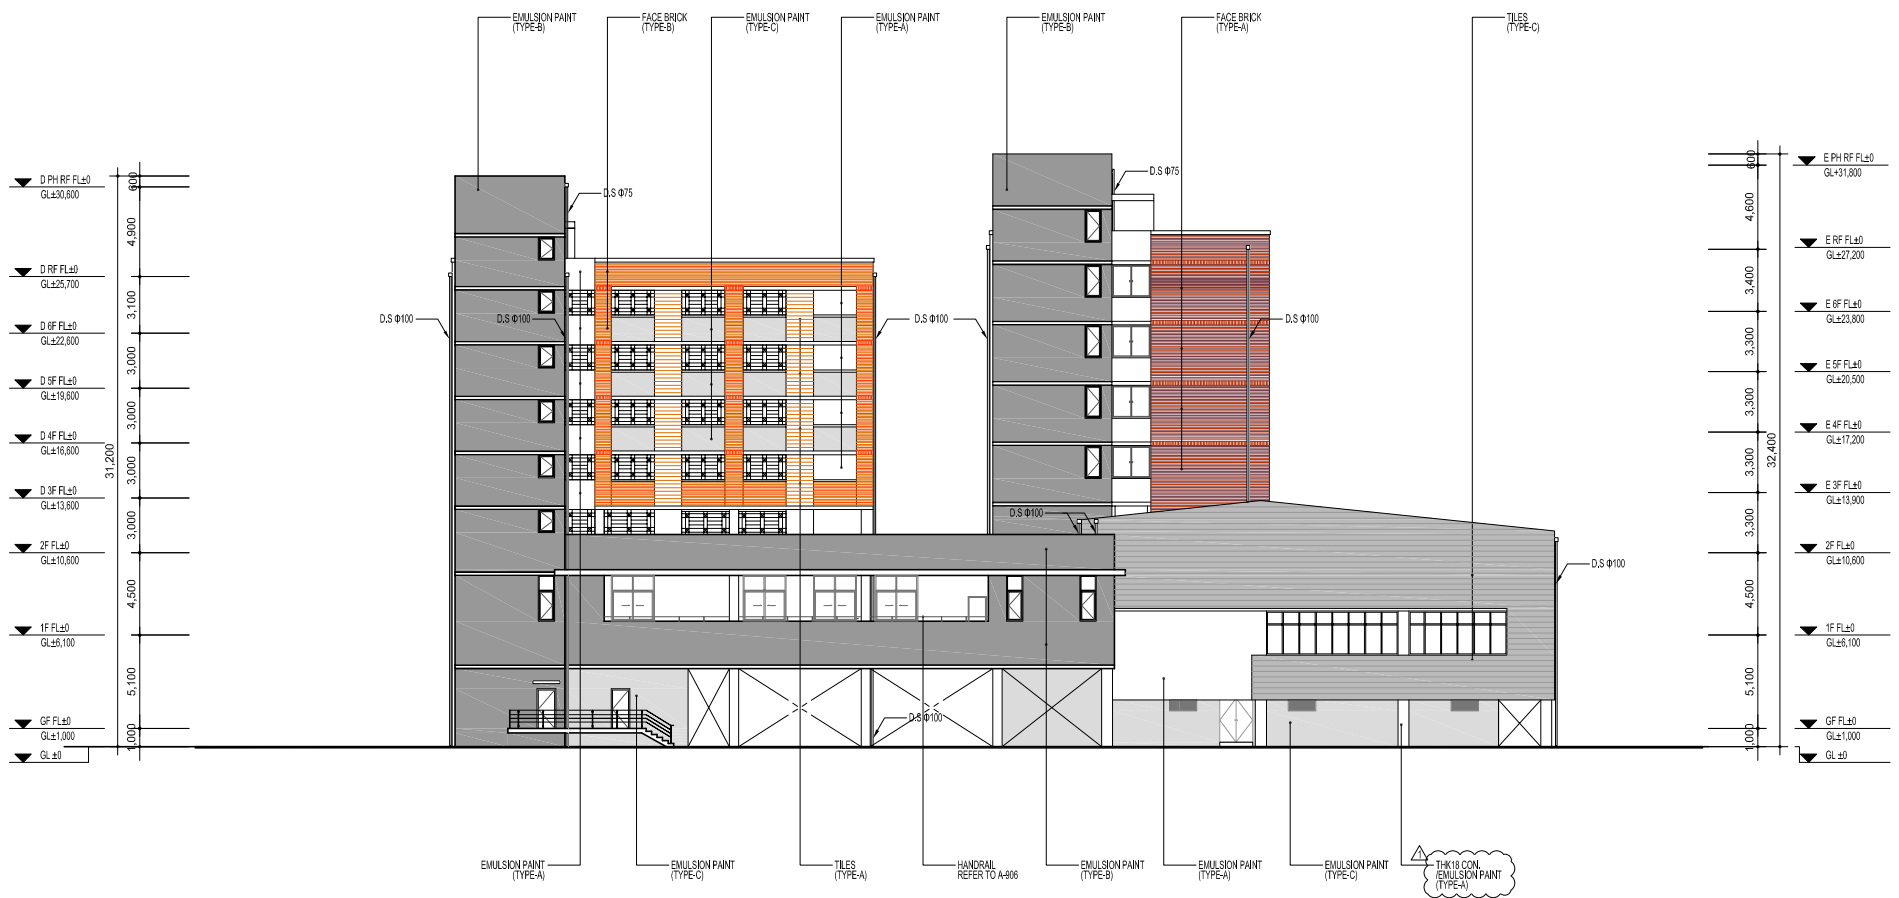

1 WEST ELEVATION
SCALE: A1 1/150
A3 1/300

△					
△					
△	2013.				
DATE	DESCRIPTION	DRW	CHK	APP	

DRAWING TITLE
WEST ELEVATION

APPROVED: Jeong, Young Kyoan *[Signature]*

CHECKED BY: Kwon, Gi Jae *[Signature]*

CHECKED: Choi, Jae Young *[Signature]*

DRAWN: Jung, Se Young *[Signature]*

PROJECT NO.: DC2013000006

SCALE	A1	A3	APPROVAL DATE
	1/150	1/300	2013. 10.

DRAWING NO.: A-305

PROJECT TITLE
Establishment of National Institute of
Advanced Practice Nurses Bangladesh

ARCHITECTS
heerim
Architects & Planners
TIL, SEOUL, KOREA TEL. 82-2-6304-1000 FAX. 82-2-6304-1075

STRUCTURAL CONSULTANTS
MIDAS IT
미디스아이티


MECHANICAL CONSULTANTS
Yungdo
YOUNGDO & CONSULTANTS

ELECTRICAL CONSULTANTS
대림이엔씨기술(주)
DAE RIM ENGINEERING & CONSTRUCTION CO., LTD.

GENERAL CONTRACTOR
Jin Young
Consultants Co., Ltd.

LANDSCAPE DESIGNERS
heerim
Architects & Planners

APPROVED BY
CHIEF ARCHITECT,
DEPARTMENT OF ARCHITECTURE
MD. AHASANUL HAQUE KHAN (SWAPAN)

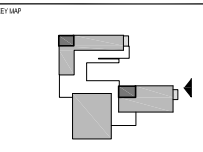


- NOTE
- FACE BRICK:
TYPE-A: RED BRICK (EDUCATIONAL FACILITIES)
TYPE-B: LIGHT RED BRICK (DORMITORY)
 - TILES:
TYPE-A: BEIGE 200x400
TYPE-B: GRAY 600x600
TYPE-C: GRAY 600x300
TYPE-D: BEIGE 600x600
 - EMULSION PAINT:
TYPE-A: WHITE COLOR
TYPE-B: DARK GRAY
TYPE-C: LIGHT GRAY

Y9 Y8 Y7 Y6 Y5 Y4 Y3 Y2 Y1



1 EAST ELEVATION
SCALE: A1 1/150
A3 1/300


△					
△					
△	2013.				
DATE	DESCRIPTION	DRW	CHK	APP	
DRAWING TITLE EAST ELEVATION					
APPROVED	Jeong, Young Kyoan <i>[Signature]</i>				
CHECKED	Kwon, Gi Jae <i>[Signature]</i>				
CHECKED	Choi, Jae Young <i>[Signature]</i>				
DRAWN	Jung, Se Young <i>[Signature]</i>				
PROJECT NO.: DC2013000006					
SCALE	A1	A3	APPROVAL DATE		
1/150		1/300	2013. 10.		
DRAWING NO.: A-306					

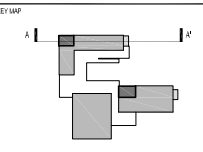

NOTE
1. LEVEL
GROUND FLOOR FL±0 = GL+1.000

△					
△	2013. 10.				
△	DATE	DESCRIPTION	DRN	CHK	APP

DRAWING TITLE A-A' SECTION					
APPROVED	Jeong, Young Kyoong				
CHECKED	Kwon, Gi Jae				
CHECKED	Choi, Jae Young				
DRAWN	Oh, Bich Na				
PROJECT NO.	DC201300006				
SCALE	A1	A3	APPROVAL DATE		
1/150	1/300		2013. 10.		
DRAWING NO.	A-311				REV.

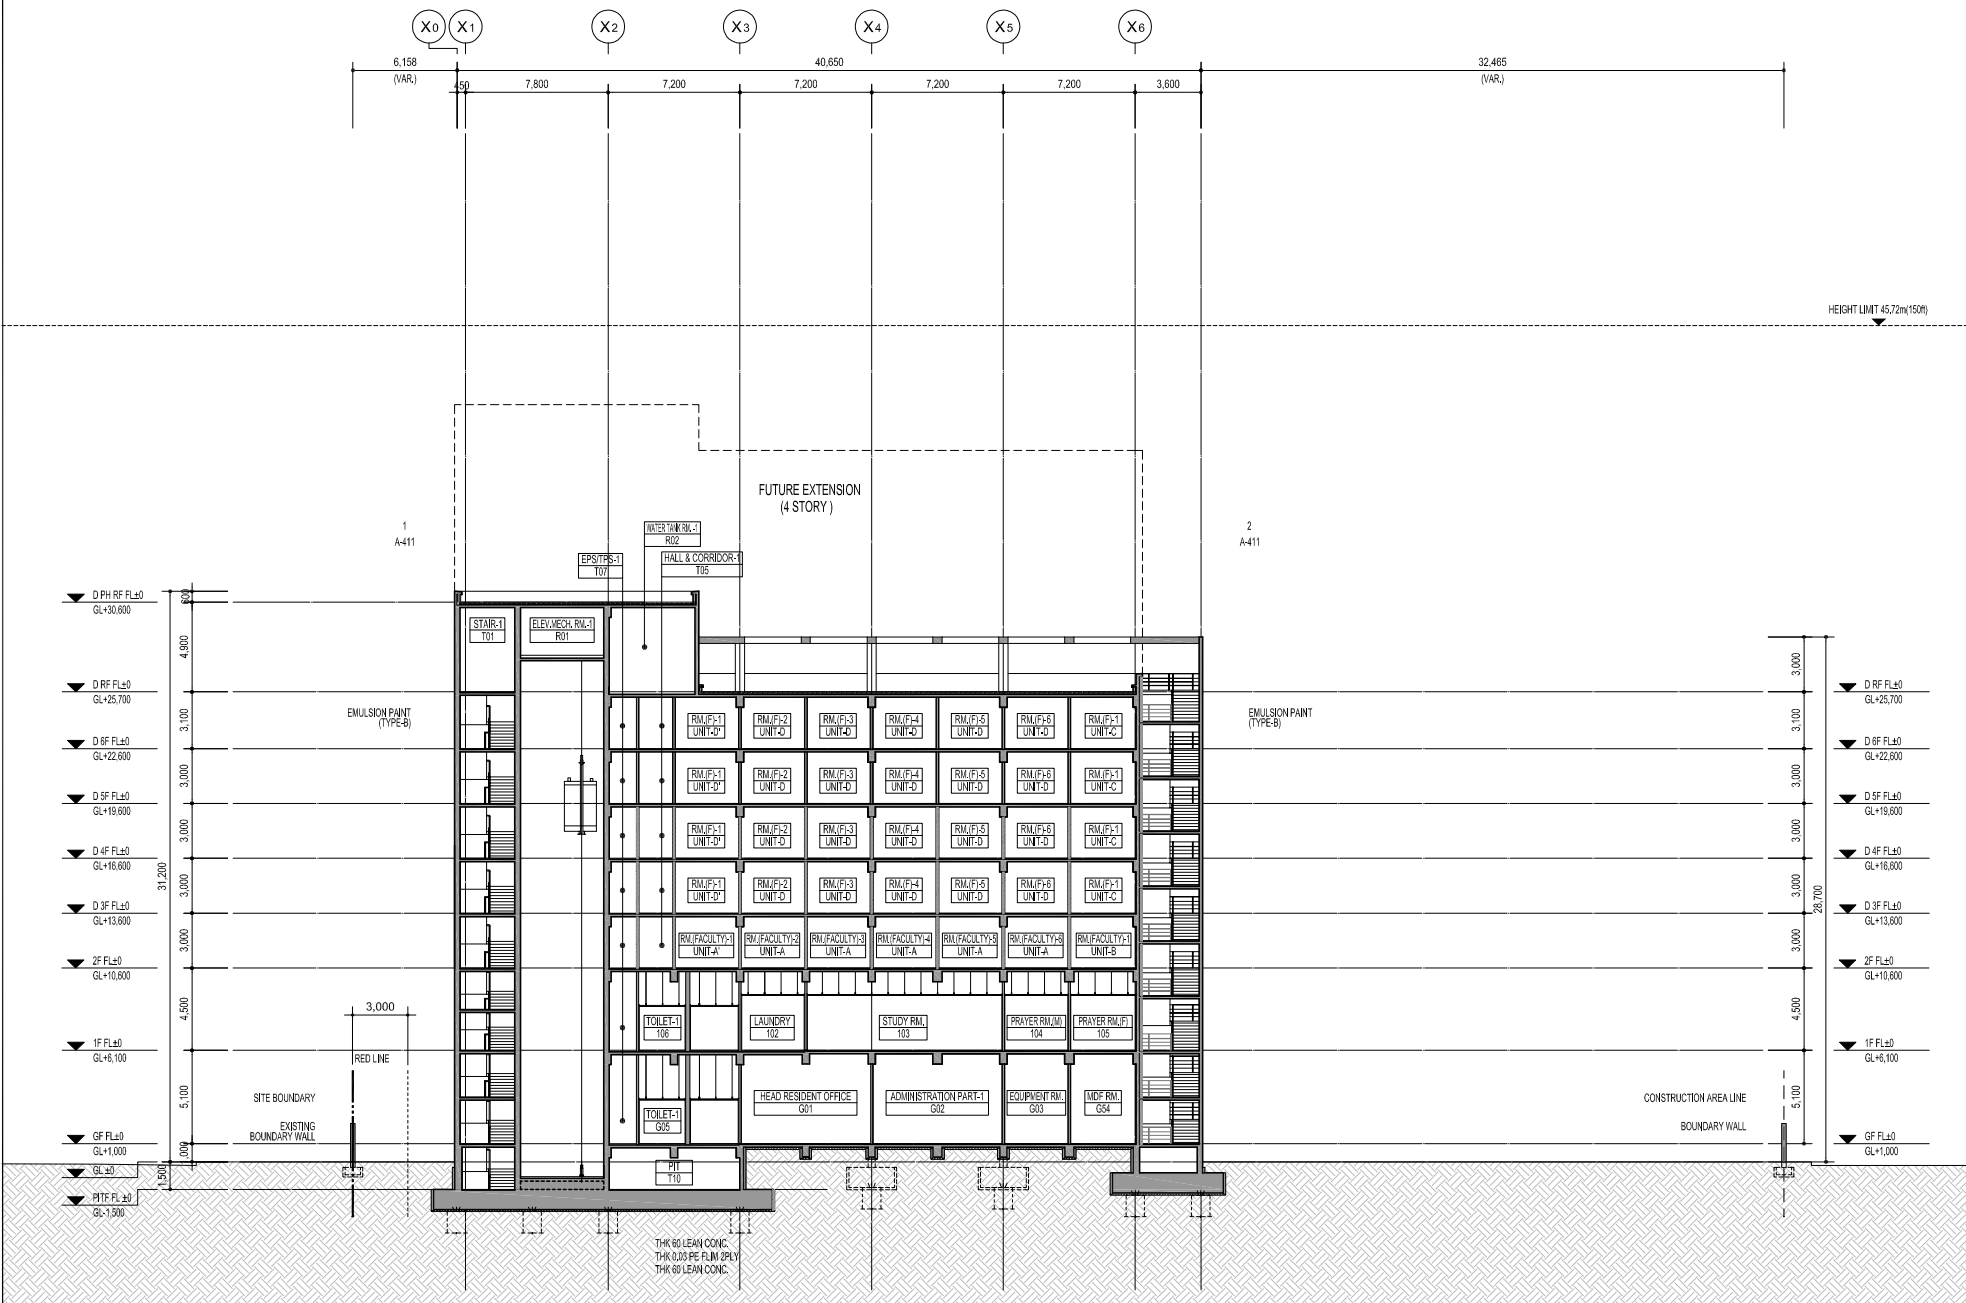

A - A' SECTION
SCALE: A1 1/150
A3 1/300

PROJECT TITLE
Establishment of National Institute of
Advanced Practice Nurses Bangladesh

ARCHITECTS
heerim
Architects & Planners
TEL: 82-2-3400-1000 FAX: 82-2-3400-1075

STRUCTURAL CONSULTANTS
MIDAS IT
미디스아이티


MECHANICAL CONSULTANTS
yungdo
엔지니어 & CONSULTANTS

ELECTRICAL CONSULTANTS
대일이엔지니어링(주)
DAEIL ENGINEERING & CONSTRUCTION CO., LTD.


GENERAL CONTRACTOR
Jin Young
Consultants Co., Ltd.

LANDSCAPE DESIGNERS
heerim
Architects & Planners

APPROVED BY
CHIEF ARCHITECT,
DEPARTMENT OF ARCHITECTURE
MD. AHASANUL HAQUE KHAN (SWAPAN)

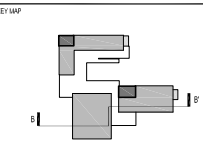


NOTE
1. LEVEL
GROUND FLOOR F.L. = GL + 1.000

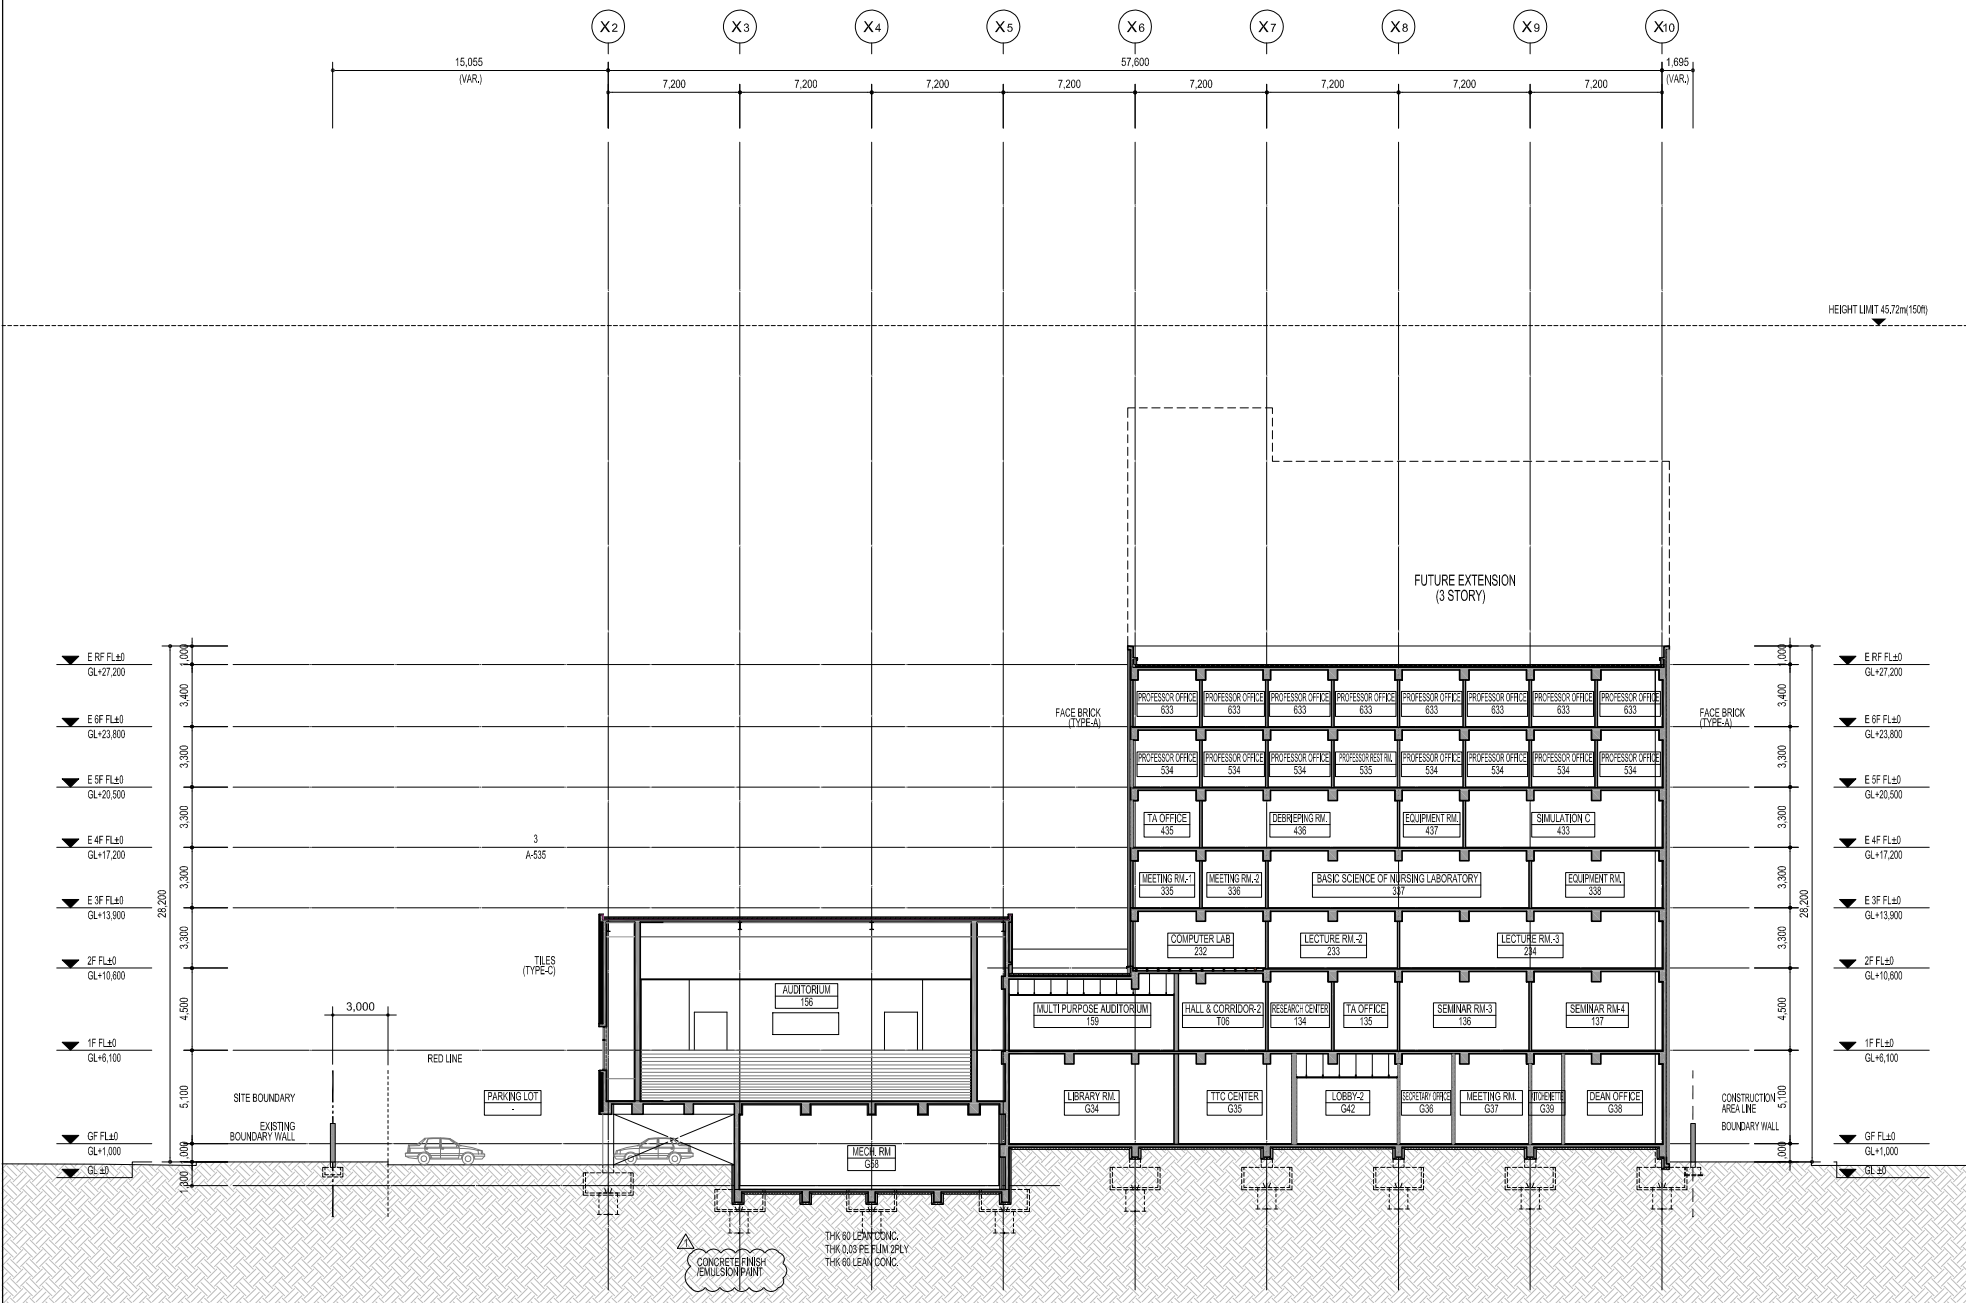


B - B' SECTION
SCALE: A1 1/150
A3 1/300

DATE	DESCRIPTION	DRN	CHK	APP

DRAWING TITLE B-B' SECTION				
APPROVED	Jeong, Young Kyoan			
CHECKED	Kwon, Gi Jae			
CHECKED	Choi, Jae Young			
DRAWN	Oh, Bich Na			
PROJECT NO.	DC2013000006			
SCALE	A1	A3	APPROVAL DATE	
1/150	1/300		2013. 10.	
DRAWING NO.	A-312			REV.

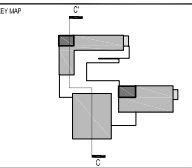


NOTE
1. LEVEL
GROUND FLOOR: FL±0 = GL+1.000

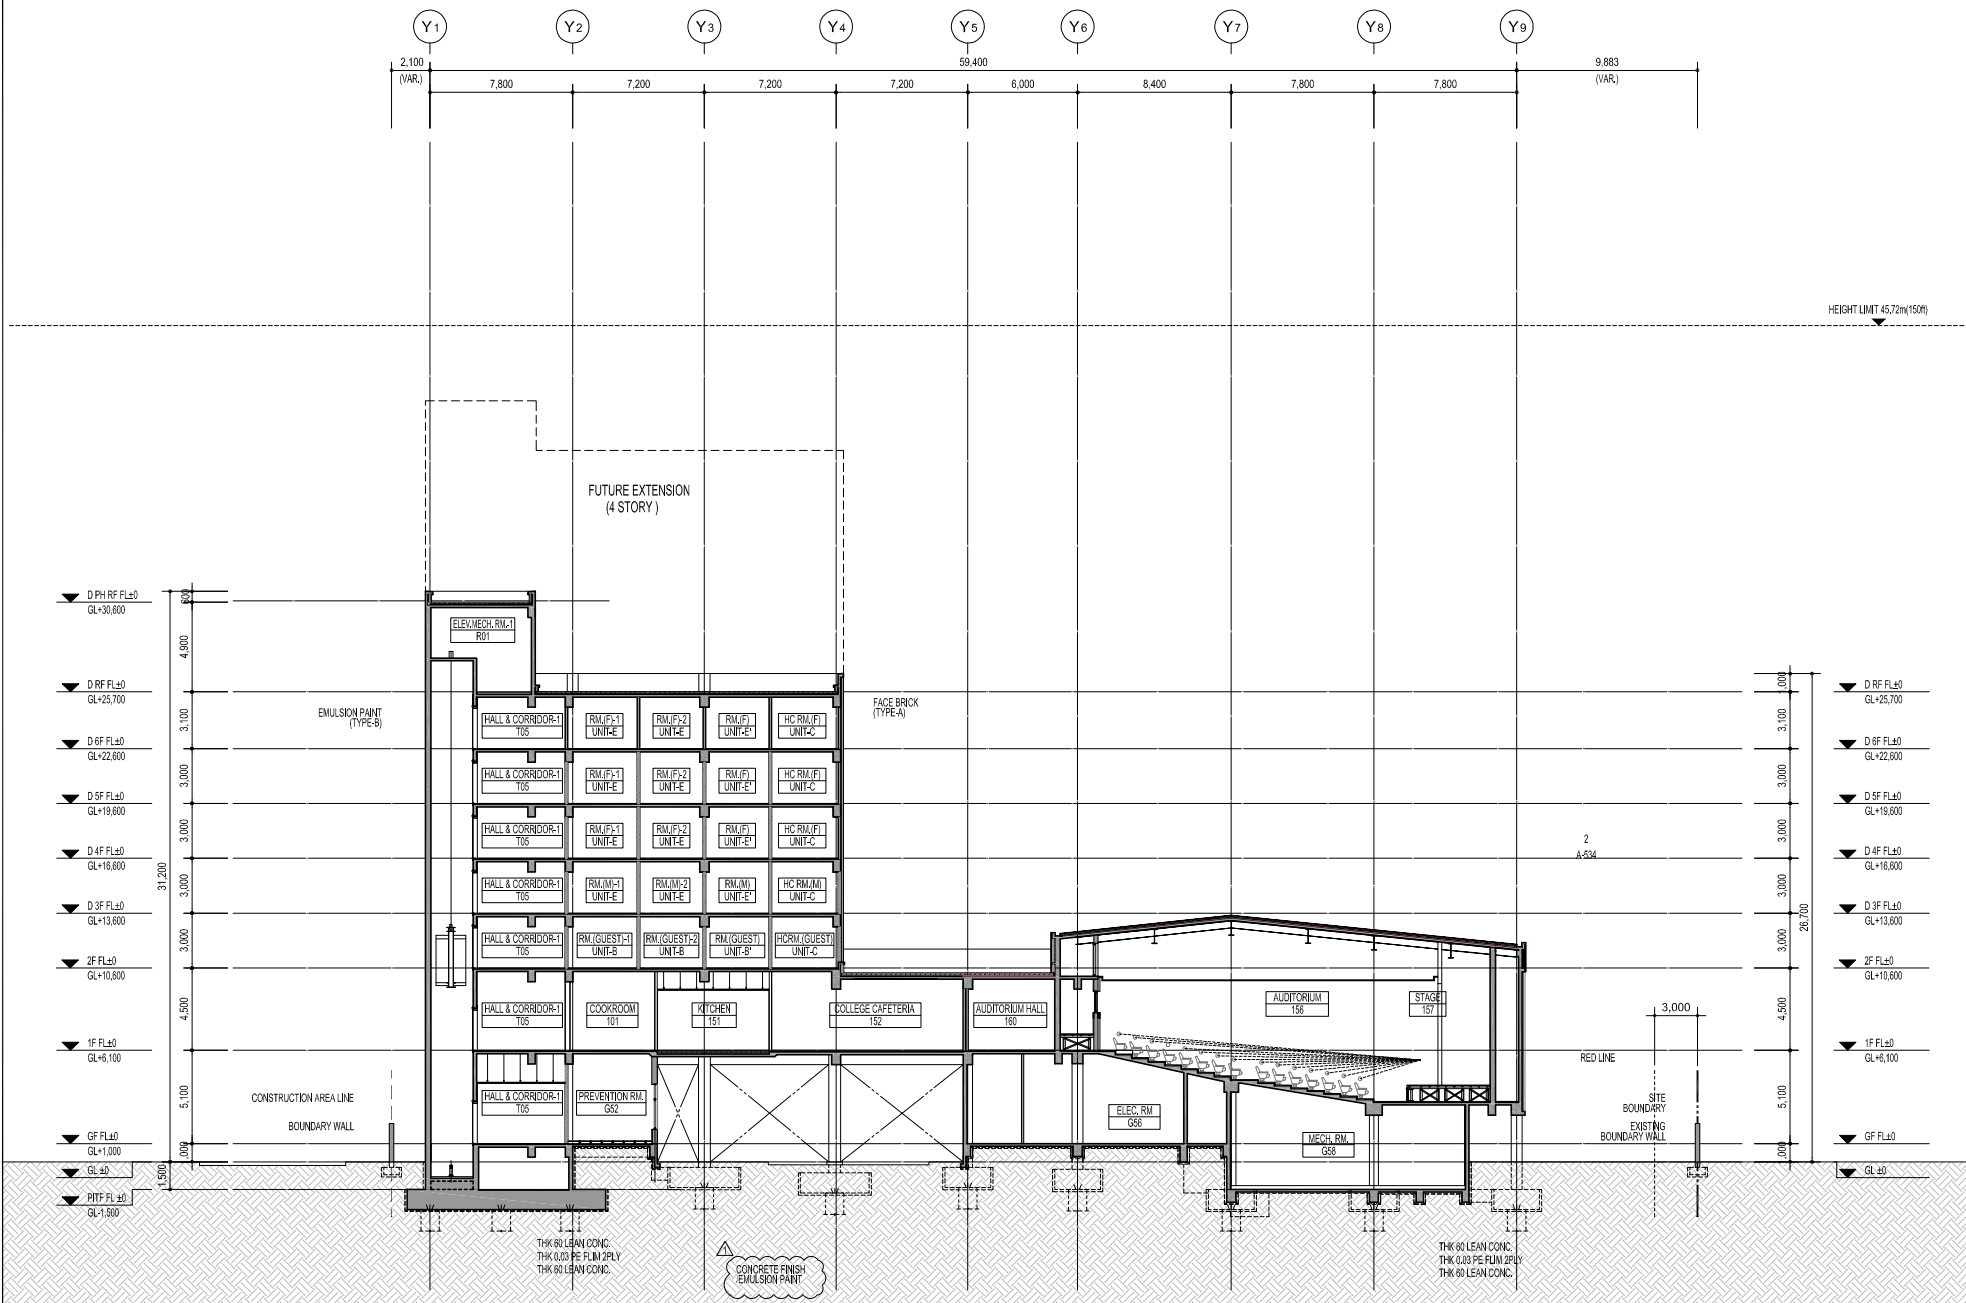

1 C - C' SECTION
SCALE: A1 1/150
A3 1/300

DATE	DESCRIPTION	DRN	CHK	APP


DRAWING TITLE C-C' SECTION				
APPROVED	Jeong, Young Kyoan			
CHECKED	Kwon, GJ Jae			
CHECKED	Choi, Jae Young			
DRAWN	Oh, Bich Na			
PROJECT NO. DC2013000006				
SCALE	A1	A3	APPROVAL DATE	
1/150		1/300	2013. 10.	
DRAWING NO.	A-313			REV.

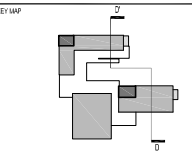

NOTE
1. LEVEL
GROUND FLOOR F.L. = G.L. + 1.000

DATE	DESCRIPTION	DRN	CHK	APP

DRAWING TITLE D-D' SECTION				
APPROVED	Jeong, Young Kyoan			
CHECKED	Kwon, GJ Jae			
CHECKED	Choi, Jae Young			
DRAWN	Oh, Bich Na			
PROJECT NO.	DC2013000006			
SCALE	A1	A3	APPROVAL DATE	
1/150	1/300	2013. 10.		REV.
DRAWING NO.	A-314			

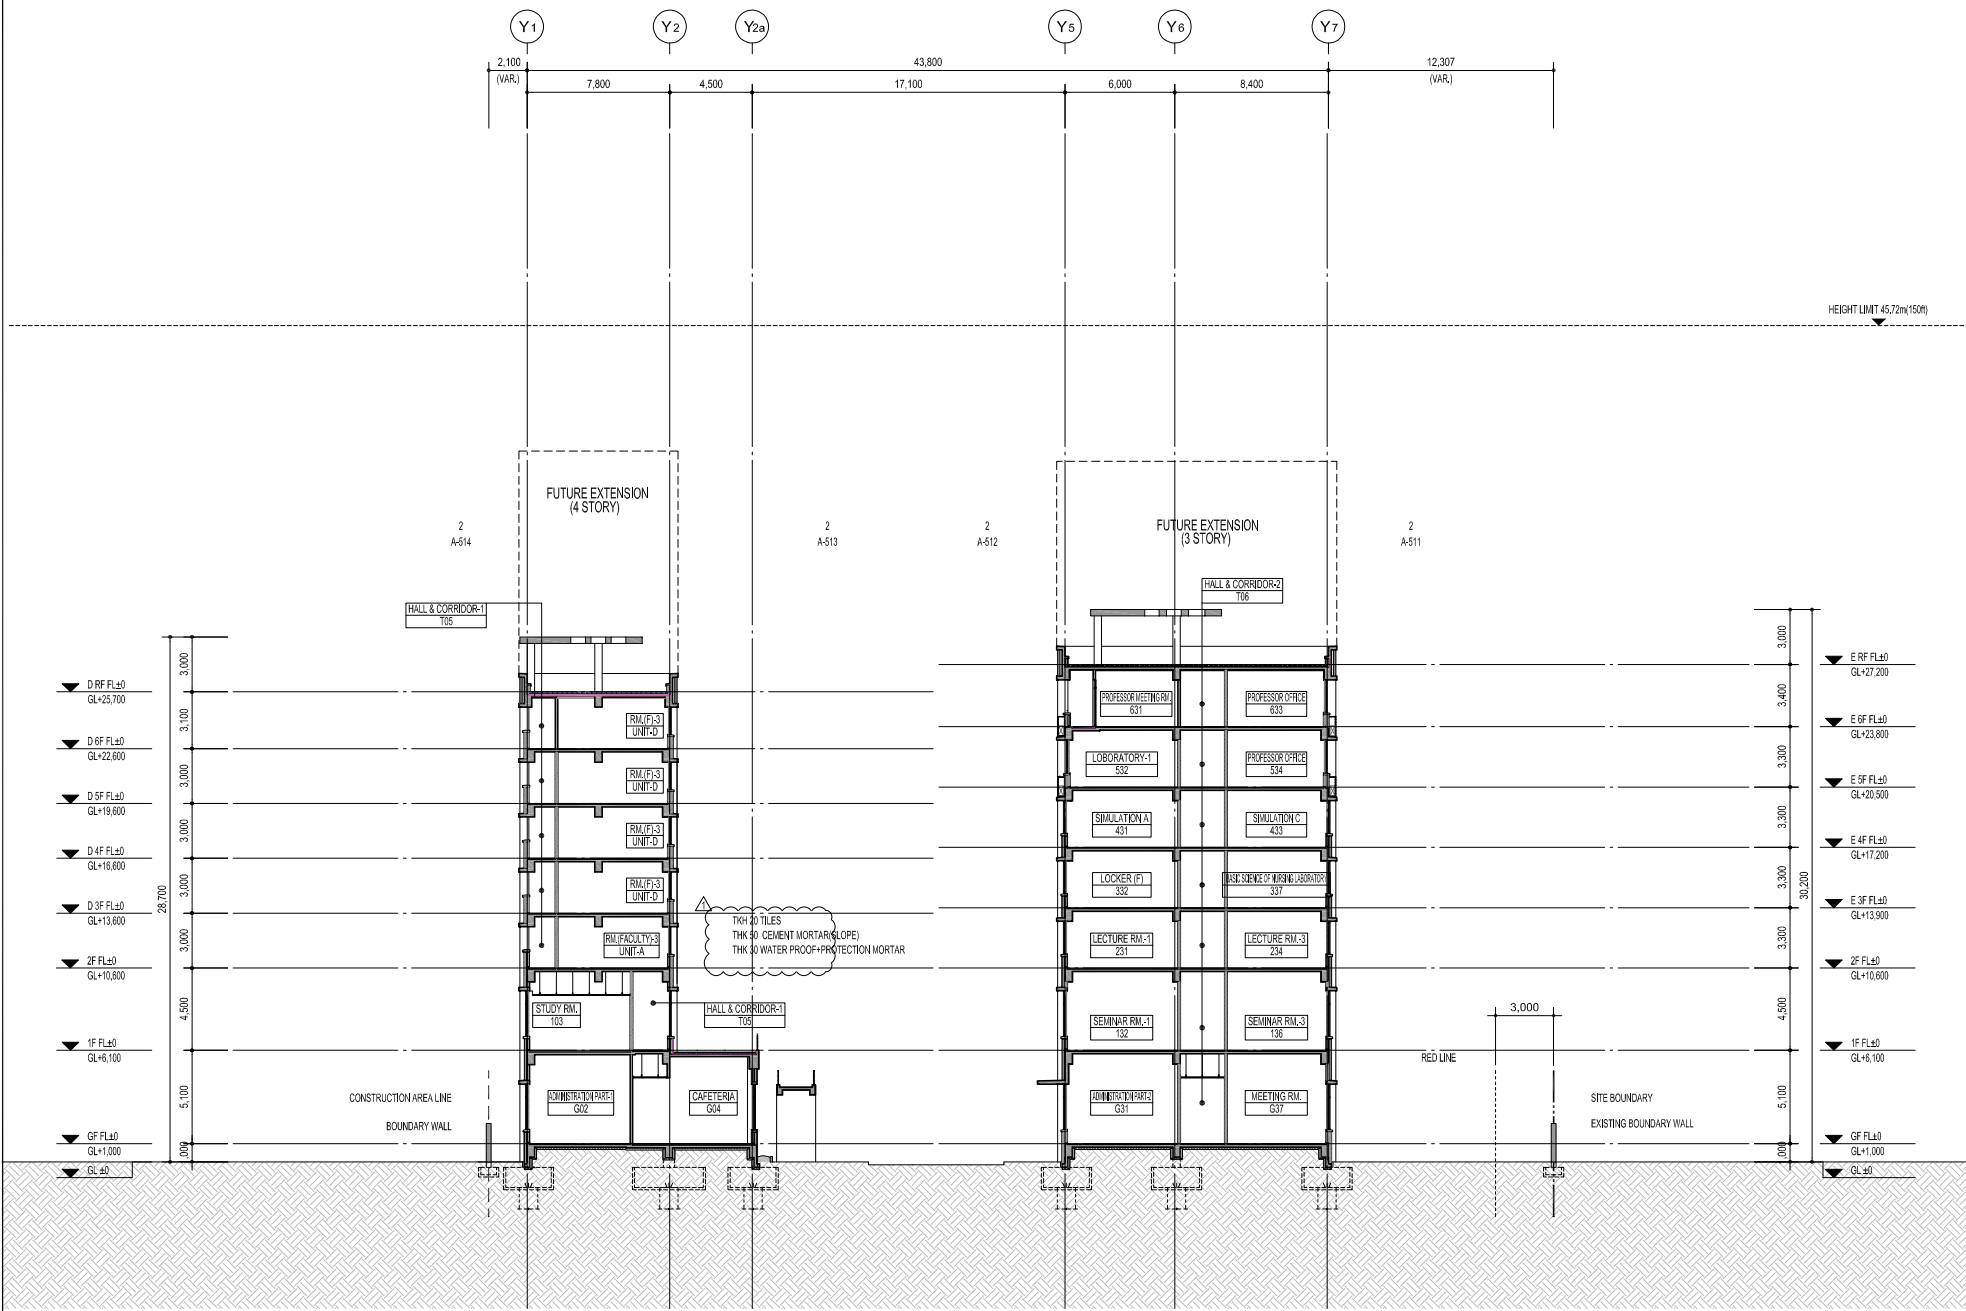

1 D - D' SECTION
SCALE: A1 1/150
A3 1/300

Additional Information (Photos of Each Room)

1. Existing Education Facility (1st floor)




Research center



Research center



Seminar room

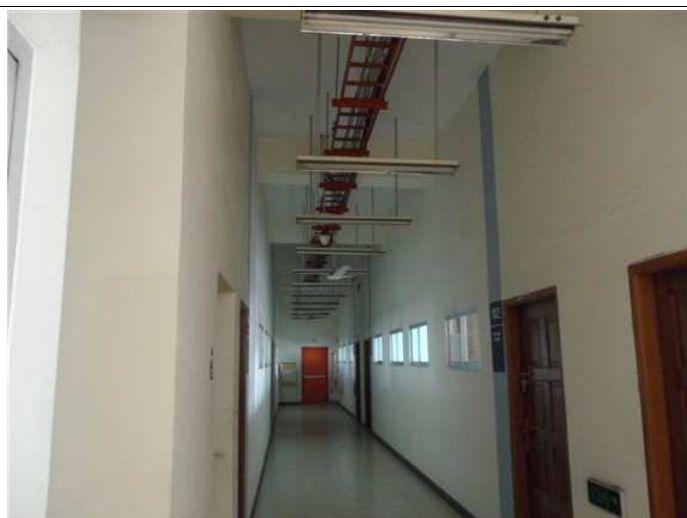

Common corridor



Elevator hall

1. Existing Education Facility (1st floor)- Auditorium & multi propose & Library (GF)



Auditorium



Auditorium



Auditorium hall



Multi propose room



Library



Library

1. Existing Education Facility (2nd floor)- Lecture room & Computer lab



Lecture room



Lecture room



Computer lab



Common toilet



Common toilet

2. Existing dormitory Facility (6th floor)




Corridor



Corridor



Guest room

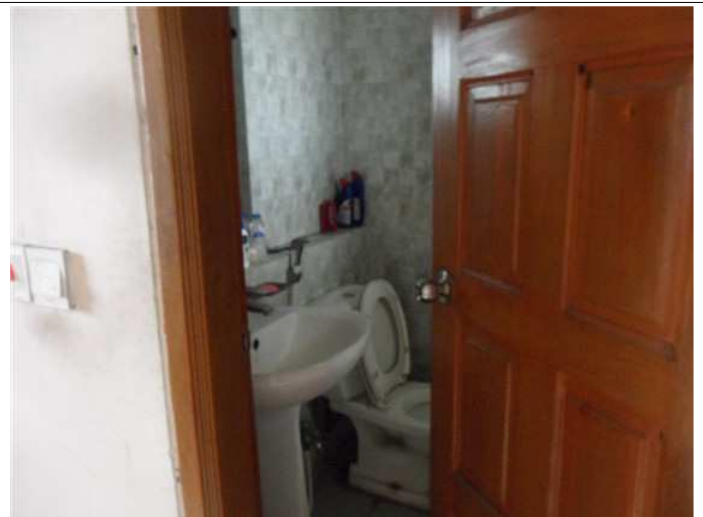

Toilet



Common area



Common area